

二层会议室&接警中心・室内精装修项目
WHOLE HOUSE CUSTOMIZATION PROJECT

项目编号: ****

出图日期: 2026年03月21日

DATE OF ISSUE: 2026-03-21

伊春居之家建筑装饰有限公司
YICHUNJUZHIIAJIANZHUZHANGSHI.CO

ABBREVIATION REFERENCE

SHEET TITLES

SHEET TITLES

GRAPHIC SYMBOLS

图例符号说明

	SPOTLIGHT 轨道照明灯		POWER SOCKET OUTLET 插座
	LED STRIP LIGHT LED灯带		SHOWER FLOOR 淋浴
	PENDANT LIGHT FIXTURE 吊灯		FLOWER POINT 花洒
	射灯		WATER PROOF SOCKET 防水插座
	二火两线两灯制		3 PHASE SOCKET 三相插座
	二火两线两灯制		ANCHION BOX 接线盒
	排烟		POWER DISTRIBUTION BOX 配电箱
	淋浴头		ROOM CONTROL UNIT 客房控制单元
	排风		EPIC 多媒体液晶显示屏
	回风		OUTLET FOR CABLE-TV 有线电视插座
	空调回风口		TELEPHONE POINT 电话插座
	空调送风口		OUTLET FOR DATA SERVICES 网络插座
	空调下出风		OUTLET FOR TELEPHONE & DATA 电话、网络插座
	空调上出风		DOOR BELL PUSH BUTTON 门铃按钮
	旋转式洒水喷头		DOOR BELL PUSH BUTTON 门铃按钮
	感烟探测器		1 GANG SWITCH 单联开关
	扬声器		2 GANG SWITCH 双联开关
	火灾探测器		3 GANG SWITCH 三联开关
	检修面板		SWITCH FOR AUTOMATIC BLIND 电动窗帘开关
	智能调光器		INFRARED SENSOR SWITCH 红外感应开关
	门磁开关		THERMOSTAT AND AIR CONTROL 空调温控器
	紧急广播		SWITCH FOR KEY CARD 感应卡取电开关
	紧急按钮		ON/OFF INDICATOR 常开/常闭指示灯

MATERIAL DESIGNATIONS

材料填充

	PLYWOOD 夾板		CEMENT CONCREAT 水泥花磚
	FINISHED WOOD 光面木		FLOOR BRICK 地磚
	PLYWOOD 木荷花		GLASS VEINS 玻璃花
	GLASS 玻璃		WOOD FLOOR 木地板(正方向)
	MIRROR 鏡子		WOOD FLOOR 木地板(斜向)
	MARBLE 大理石		MIRROR 鏡面磚
	CONCRETE BLOCK 預混土塊		MARBLE 大理石
	BRICK 磚		MARBLE VEINS 大理石花紋與鋼帶

SHEET TITLE REFERENCE

图标说明

AD	OR	DT	ARCHITECTURAL DETAIL	断面构造图
FF			FIXTURE & FURNISHING PLAN	平面布置图
FP			KEY PLAN	平面索引图
FA			ARCHITECTURAL INFO. PLAN	平面功能尺寸图
FC			FLOOR COVERING PLAN	地面材料平面图
FI			FIXTURE & FURNITURE PLAN	平面家具布置图
RC			REFLECTED CEILING PLAN	天花布置图
EM			ELECTRICAL / MECH. PLAN	机电平面图
E			INTERIOR ELEVATIONS	立面图
DT			DETAIL	大样图
DS			DOOR SCHEDULE	门表
AMP			ARCHITECTURAL INFORMATION PACKET	图纸目录

MATERIAL FINISH REFERENCE

材料缩写代号说明

ARF	ARCHITECTURAL FINISH	建築完成面
T	CERAMIC TILE	瓷片
	FLOOR TILE	地磚
ND	CARPET	地毯
WYP	GYPSUM WALL BOARD	石膏板
MT	METAL FINISH	金屬漆
WT	STAINLESS STEEL	不銹鋼
ND	WOOD FINISH	木作面
ST	STONE	石材、石工
PL	PLYWOOD	夾板、膠板
WC	WALL PAPER	牆紙
UP	UPHOLSTERY	布面
GL	GLASS	玻璃
MR	MIRROR	鏡子
PT	PAINT	塗料、油漆

MISCELLANEOUS

其它代号缩写说明

A	ARCHITECTURAL FINISH	艺术品和装饰
F	FAMILY PROPERTY	活动家具
L	LAMP AND LANTERNS	灯具
L	HARDWARE, FITTINGS	五金配件
S	SANITARY EQUIPMENT	卫生设备
E	EQUAL	相等, 平等
NO	WOOD FINISH	木饰面
UP	UPPER	上
BE	BELOW	下
UP	UPHOLSTERY	室内陈设物
AIR	AIR CONDITIONER	空调
FH	FIRE HYDRANT	消防栓

GRAPHIC SYMBOLS

图例符号说明

	COLUMN CENTERLINE DESIGNATION	轴号
	MATERIAL CHARACTERISTICS	材料缩写
	BILL OF MATERIALS	材料代号
	DEVICE CHARACTERISTICS	设备材料缩写
	DEVICE CODE PABE	设备材料代号
	DEVICE NAME	设备材料名称
	HEIGHT ABOVE FINISHED FLOOR	天花标高
	MATERIAL CHARACTERISTICS	天花材料代号
	BILL OF MATERIALS	天花材料代号
	MATERIAL TRADEMARK	天花材料名称
	SECTION PLANE SECTION NUMBER	剖面代号
	SECTION PLANE	剖面图
	DETAIL REFERENCE NUMBER	大样代号
	SHEET NUMBER	图纸序号
	SHEET TITLE REFERENCE	大样范围
	ARCHITECTURAL FINISH	图例类型缩写
	ARCHITECTURAL FINISH	图例类型
	ARCHITECTURAL FINISH	图例比例
	ARCHITECTURAL FINISH	图例比例
	ARCHITECTURAL FINISH	立面绝对标高
	ARCHITECTURAL FINISH	立面相对标高
	ARCHITECTURAL FINISH	平面绝对标高
	ARCHITECTURAL FINISH	立面标题号
	SHEET TITLE REFERENCE	立面索引图号
	ELEVATION REFERENCE NUMBER	立面索引号
	DOOR	门符代号
	DENOTES AREA OF CHANGE	改变指示区域
	DENOTES AREA OF HOLD	保持指示区域
	ACCESSIBLE	可进入
	-CONNECTING DOOR	接门
	-DOOR/KEY	门/锁

[illegible][illegible]

INTERIOR ARCHITECTURAL INFORMATION PACKAGE

SHEET INDEX

Copyright reserved. All information and copyright in this drawing and above are the property of the designer and should not be used or reproduced without the consent of the Designer.

凡属工程上所有资料及图样均受法律保护。

未经书面许可不得复制或传播。

All dimensions shall be verified by the contractor on site prior to the commencement of work.

施工前应核实尺寸，未经书面许可不得变更。

DRAWING TITLE 圖名

DRAWN 繪圖

CHECKED 审核

SCALE 比例 N • T • S



PAGECOUNT 总页数	DATE 出图日期
---------------	-----------

共7页	2026-03-21
-----	------------

PROJECT NO. 项目编号	VERSION NO. 版本号
------------------	-----------------

01	1.0
----	-----

DRAWING NO. 图号

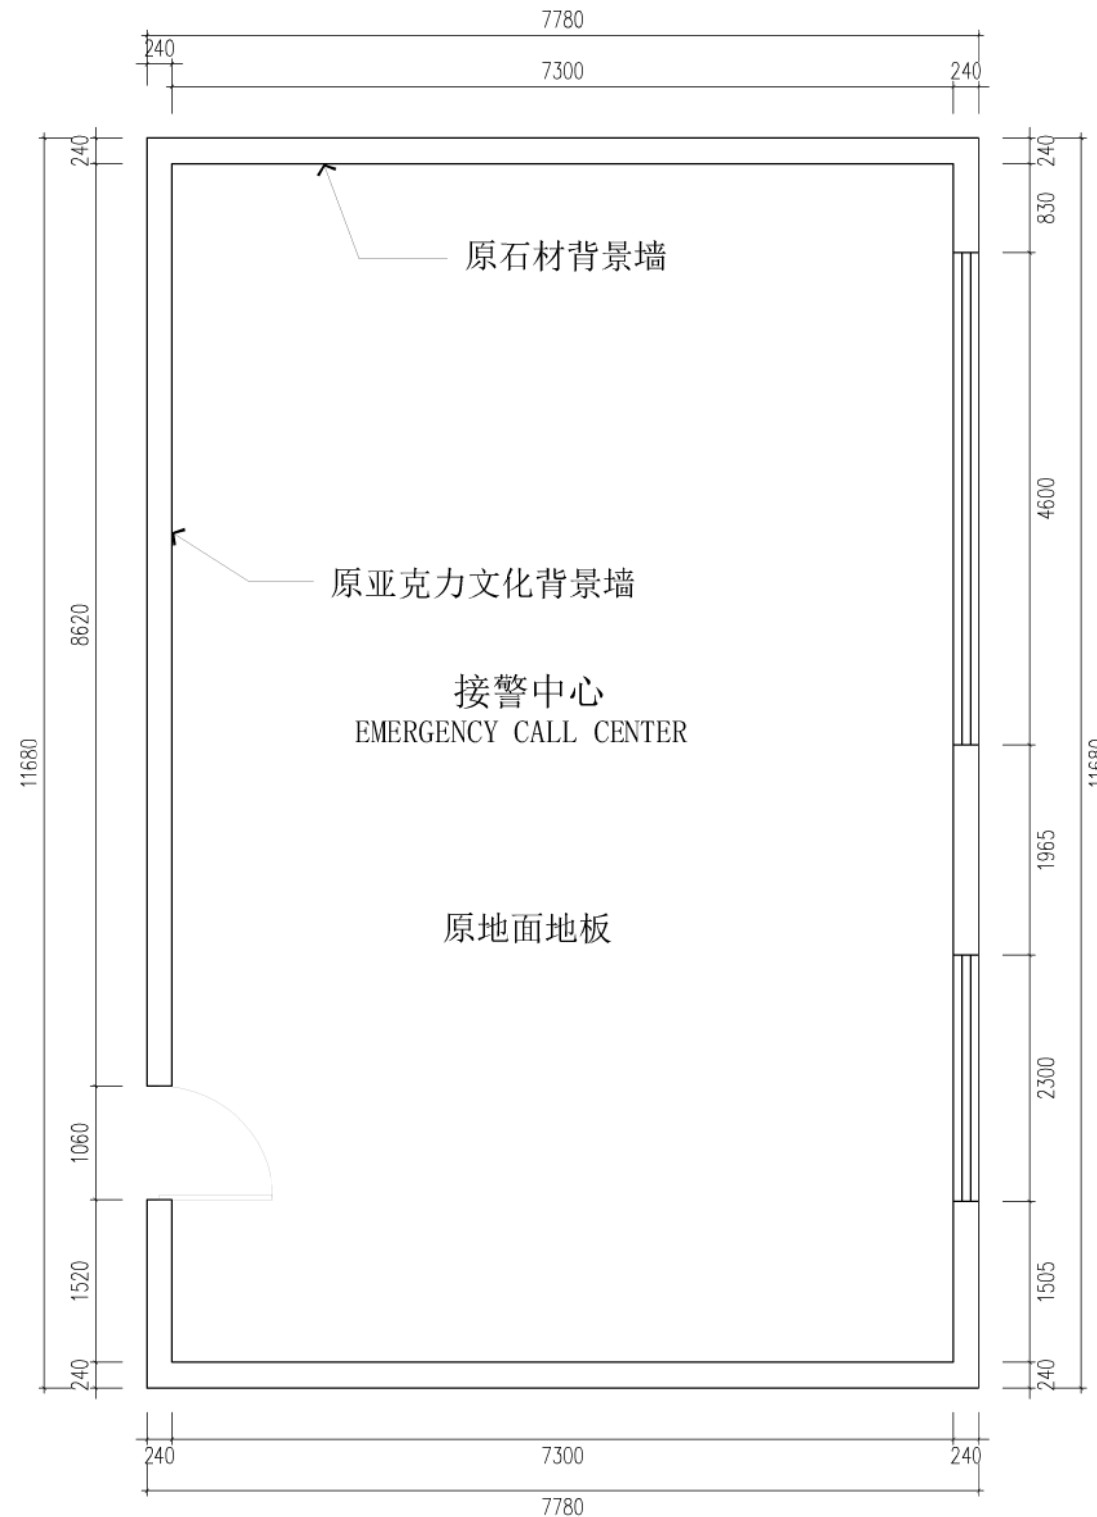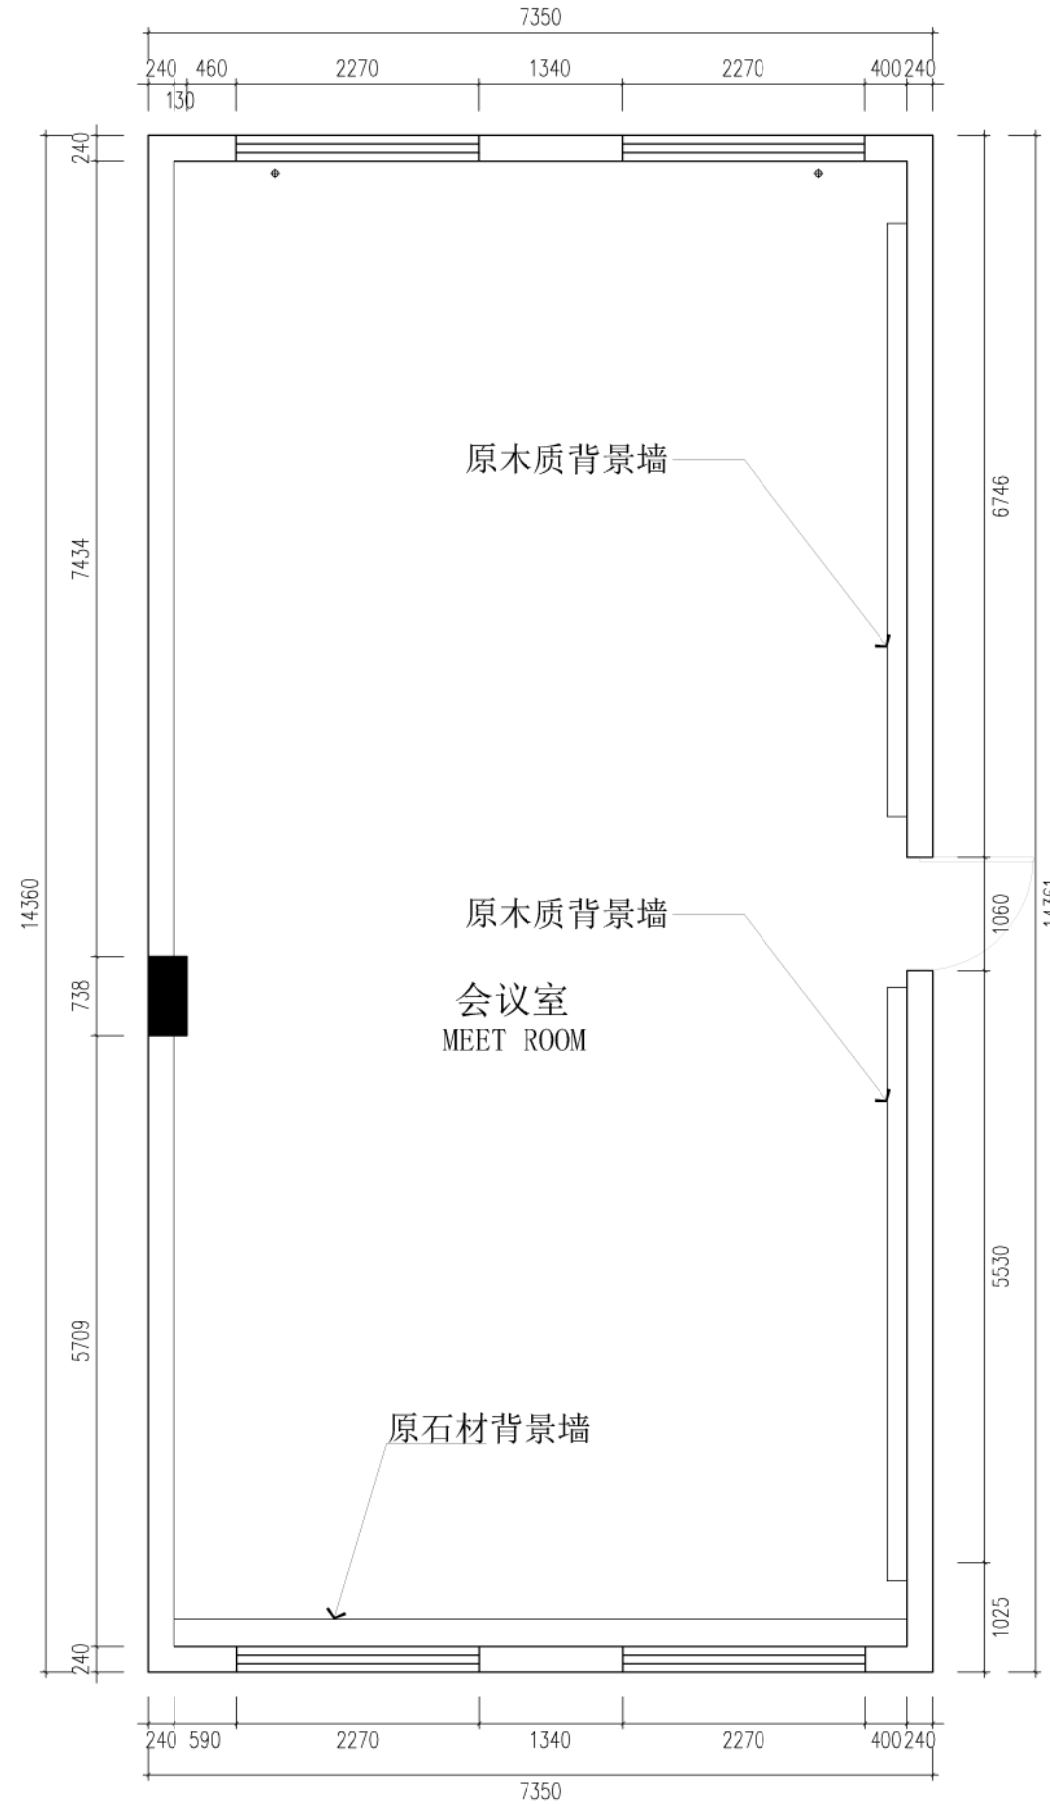

ORIGINAL ARCHITECTURAL DRAWINGS
原始建筑图



SCALE 1: 50

需现场测量尺寸为准

Copyright reserved. All information and copyright in this drawing shall be the property of the designer, and should not be used or reproduced without the consent of the Designer.
All drawings shall be verified by the contractor on site prior to the commencement of work.
本项目所有版权及设计权归设计方所有。
所有图纸必须在开工前经承包商现场核实。

PROJECT 项目	
指挥大厅二层	
DRAWING TITLE 图名	
原始建筑图	
DRAWN 制图	
CHECKED 审核	
SCALE 比例	
SCALE@ 1:50	
PAGECOUNT 页数	DATE 绘图日期
19	2026-03-24
PROJECT NO. 项目编号	VERSION NO. 版本号
01	1.0
DRAWING NO. 图号	
P-2F-01	

名称	图例
剪力墙体	
原建筑墙	
拆扒墙体	

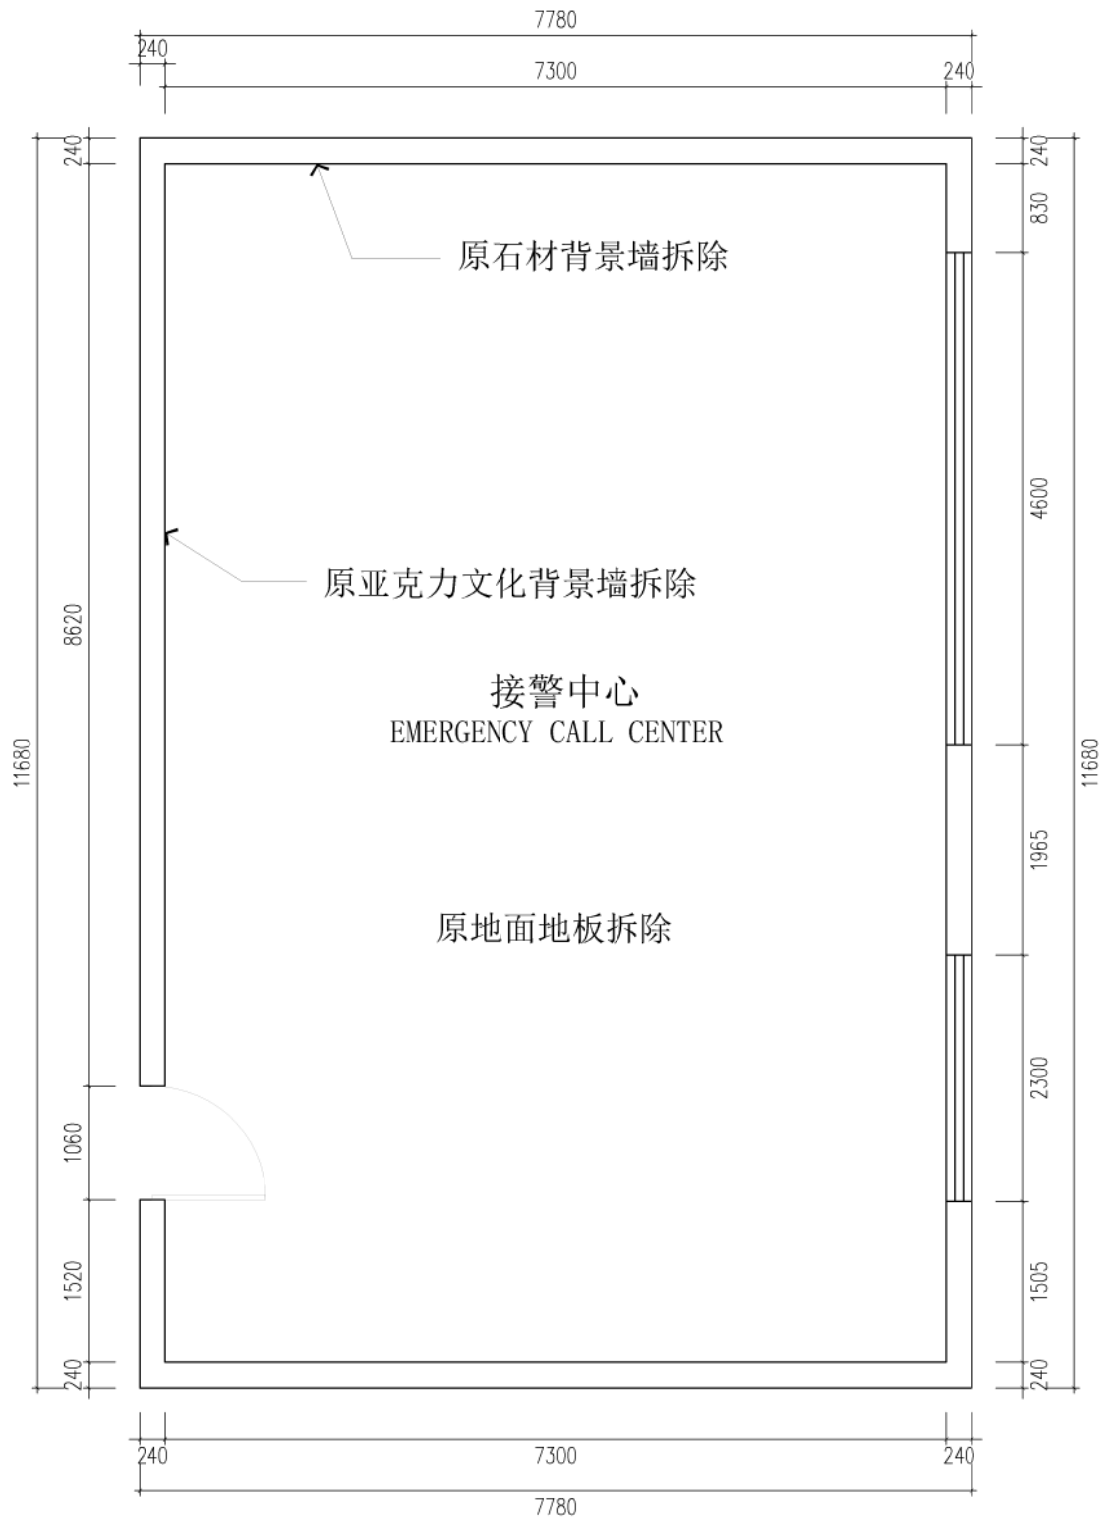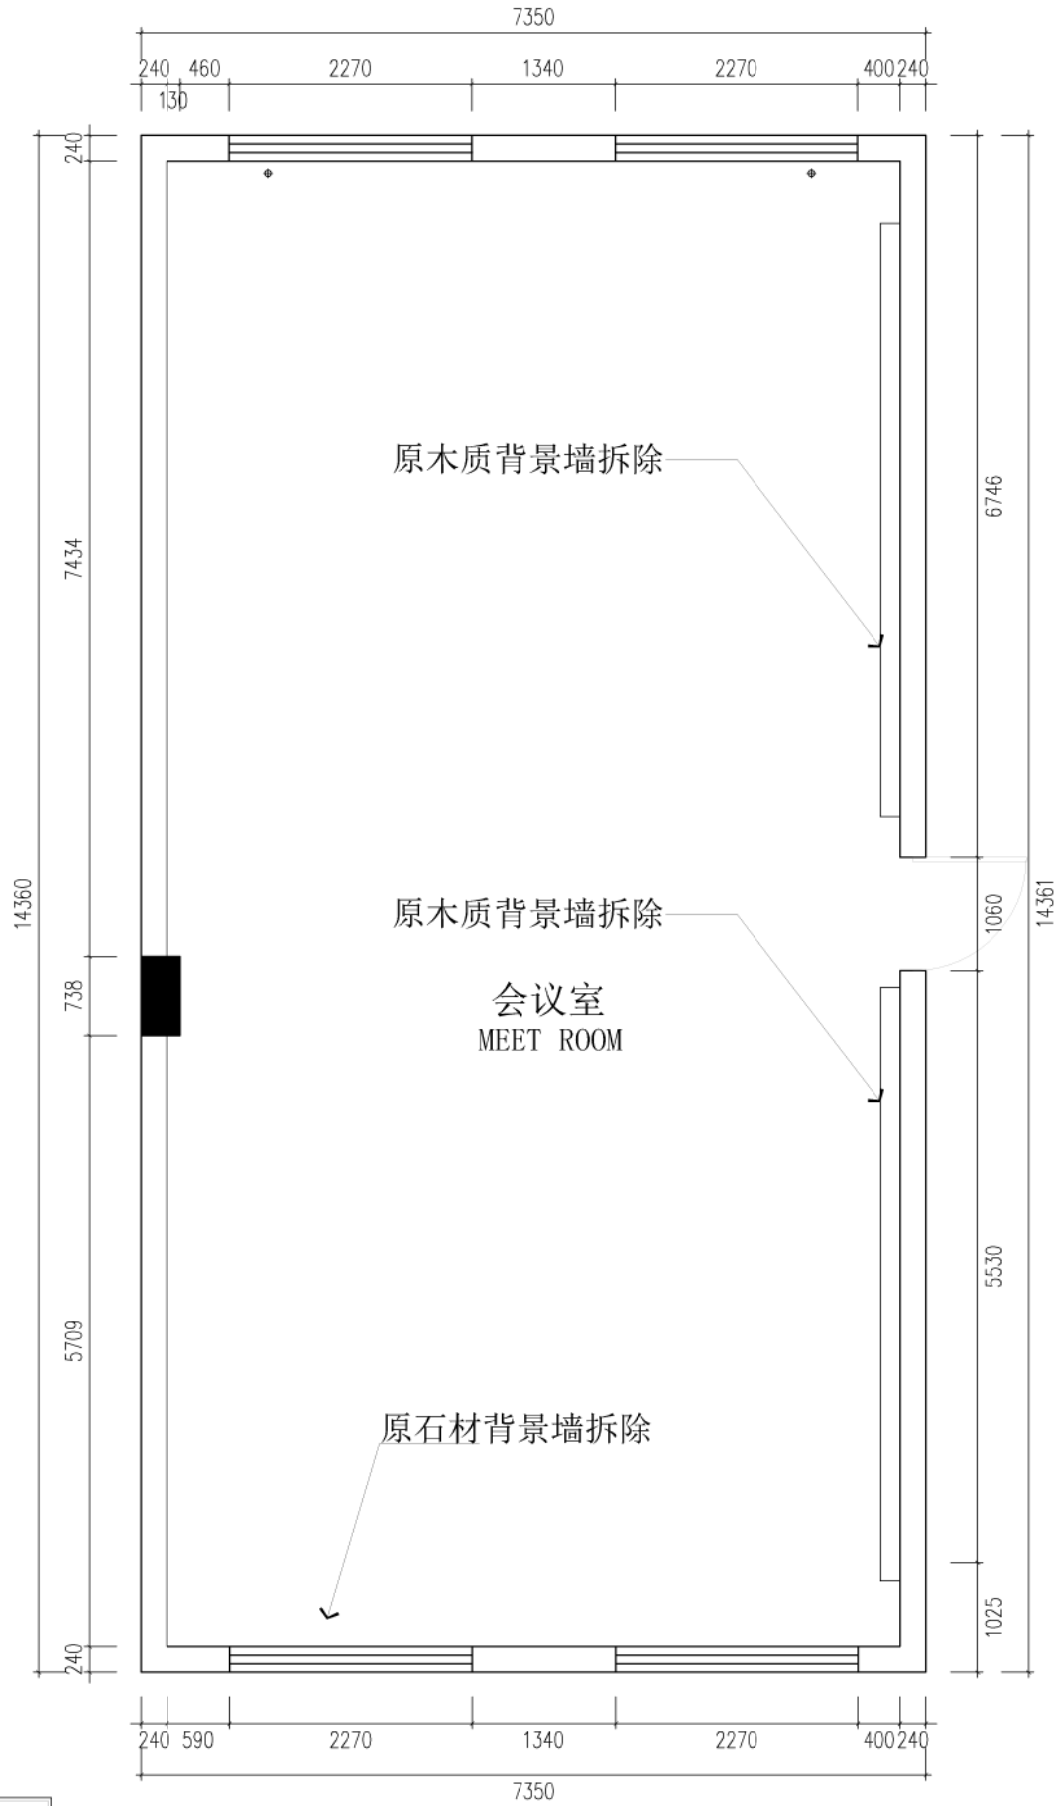



WALL DISMANTLING DIAGRAM
墙体拆扒图

SCALE 1: 50

接警室，换地板，文化墙拆除，墙面喷漆，
会议室，重做背景墙

Copyright reserved. All information and copyright in this drawing and design are the property of the designer, and should not be used or reproduced without the consent of the Designer.
本图及设计内容均受法律保护，未经许可，不得复制或传播。
All dimensions shall be verified by the contractor on site prior to the commencement of work.
施工前应现场核实尺寸，在开始施工前进行确认。

PROJECT 项目	指挥大厅二层
DRAWING TITLE 图名	墙体拆扒图
DRAWN 制图	
CHECKED 审核	
SCALE 比例	SCALE@ 1:50
PAGE/COUNT 页码	19
DATE 绘图日期	2026-03-24
PROJECT NO. 项目编号	01
VERSION NO. 版本号	1.0
DRAWING NO. 图号	P-2F-02

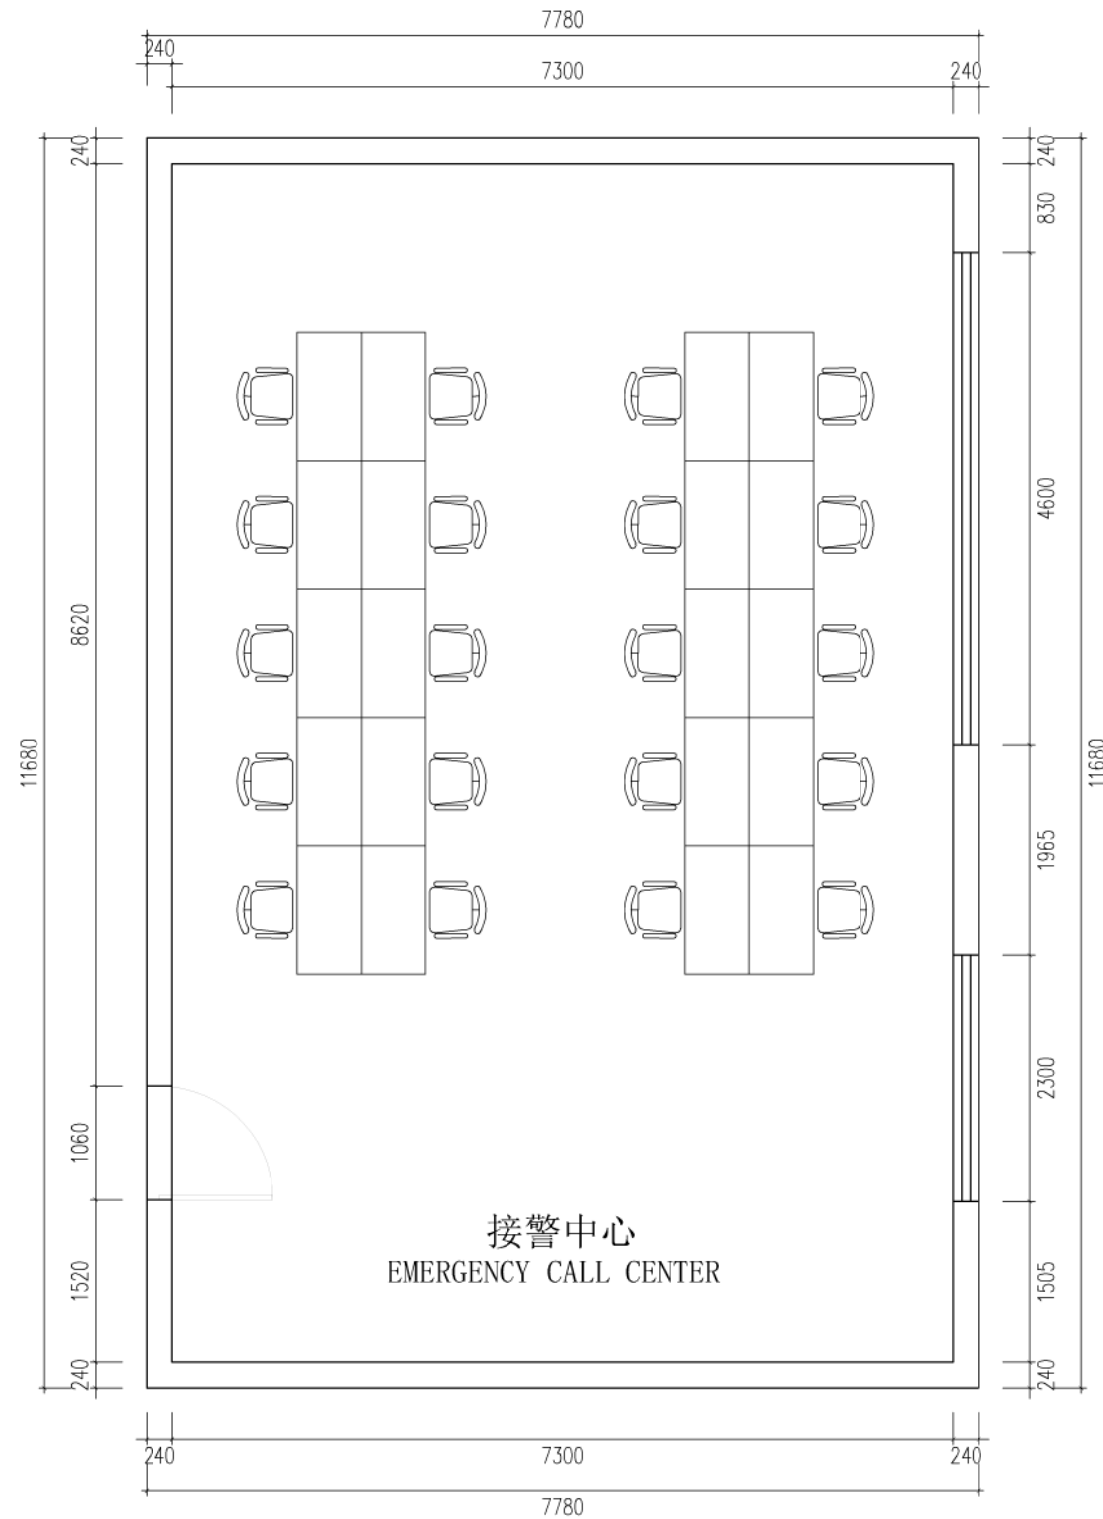
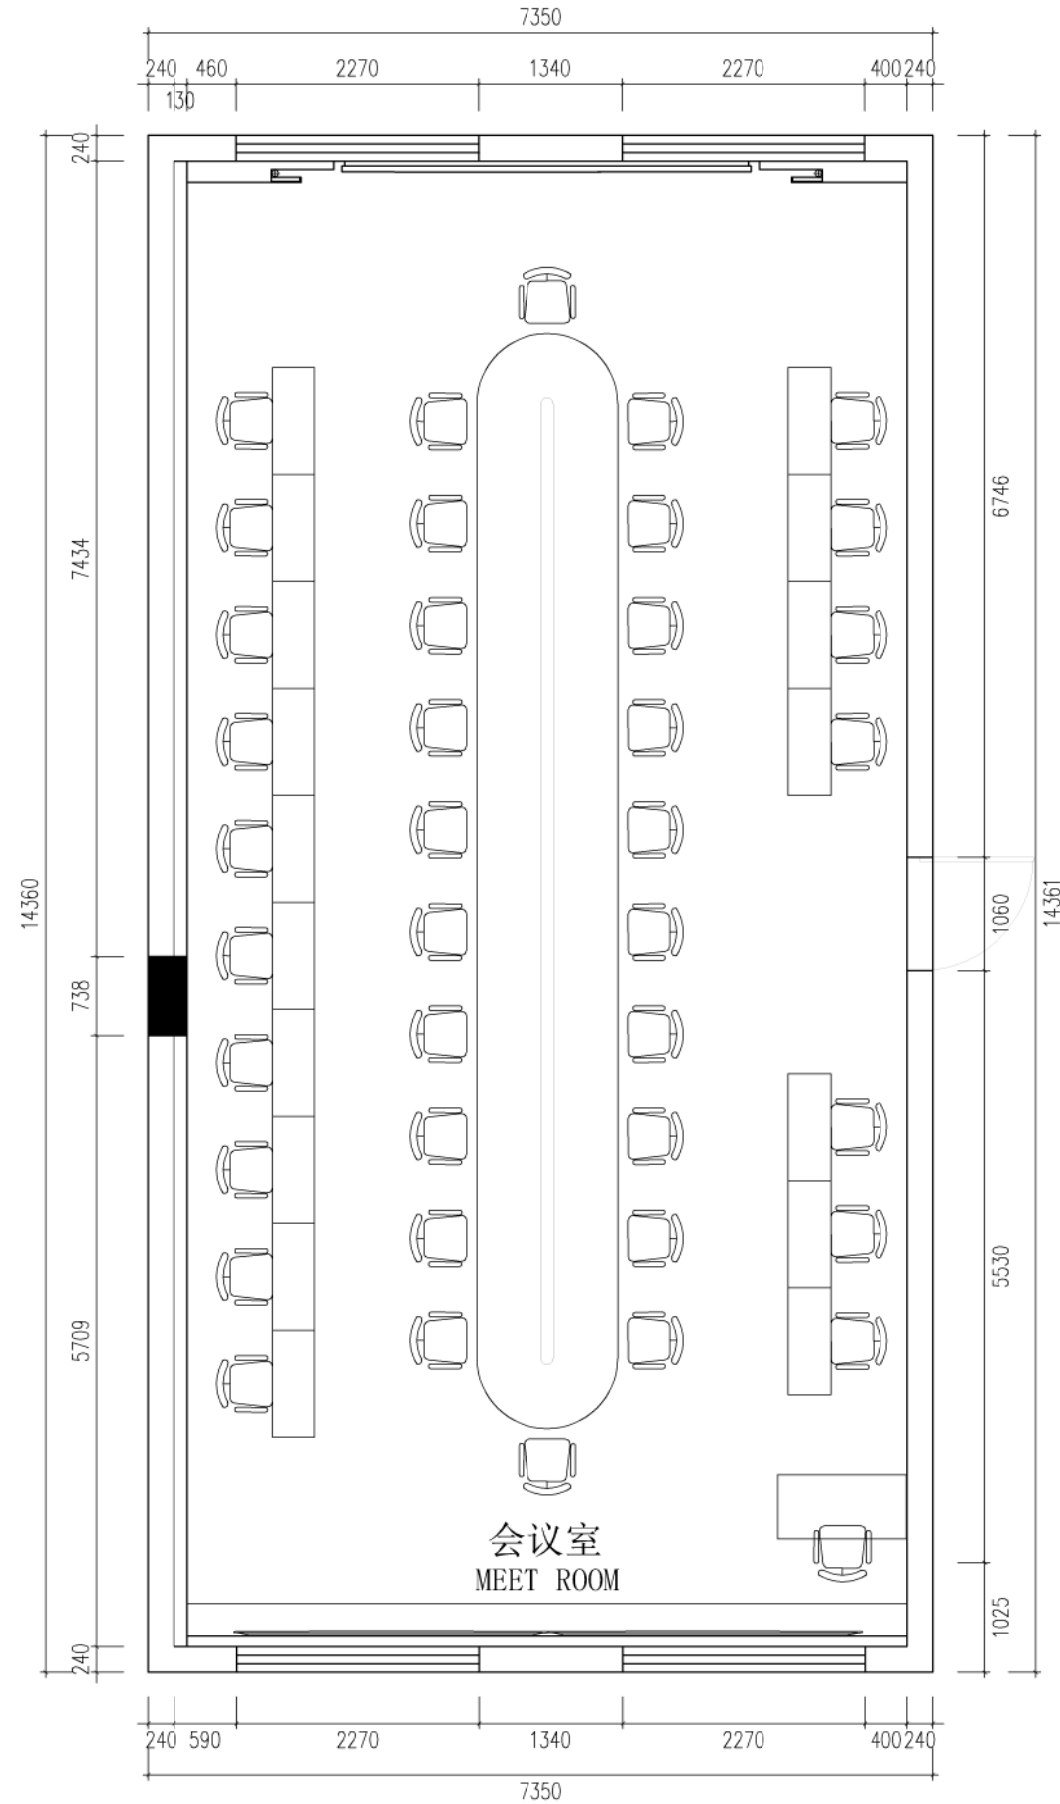


ELECTRICAL & FURNITURE LAYOUT PLAN
平面布置图

SCALE 1: 50

Copyright reserved. All information and copyright in this drawing and design are the property of the designer, and should not be used or reproduced without the consent of the Designer.
All dimensions shall be verified by the contractor on site prior to the commencement of work.
本图版权归设计单位所有，未经许可，不得复制或传播。
所有尺寸应在开工前由承包商在现场核实。

PROJECT 项目	
指挥大厅二层	
DRAWING TITLE 图名	
平面布置图	
DRAWN 制图	
CHECKED 审核	
SCALE 比例	
SCALE@ 1:50	
PAGECOUNT 页码	DATE 日期
19	2026-03-24
PROJECT NO. 项目编号	VERSION NO. 版本号
01	1.0
DRAWING NO. 图号	
P-2F-03	

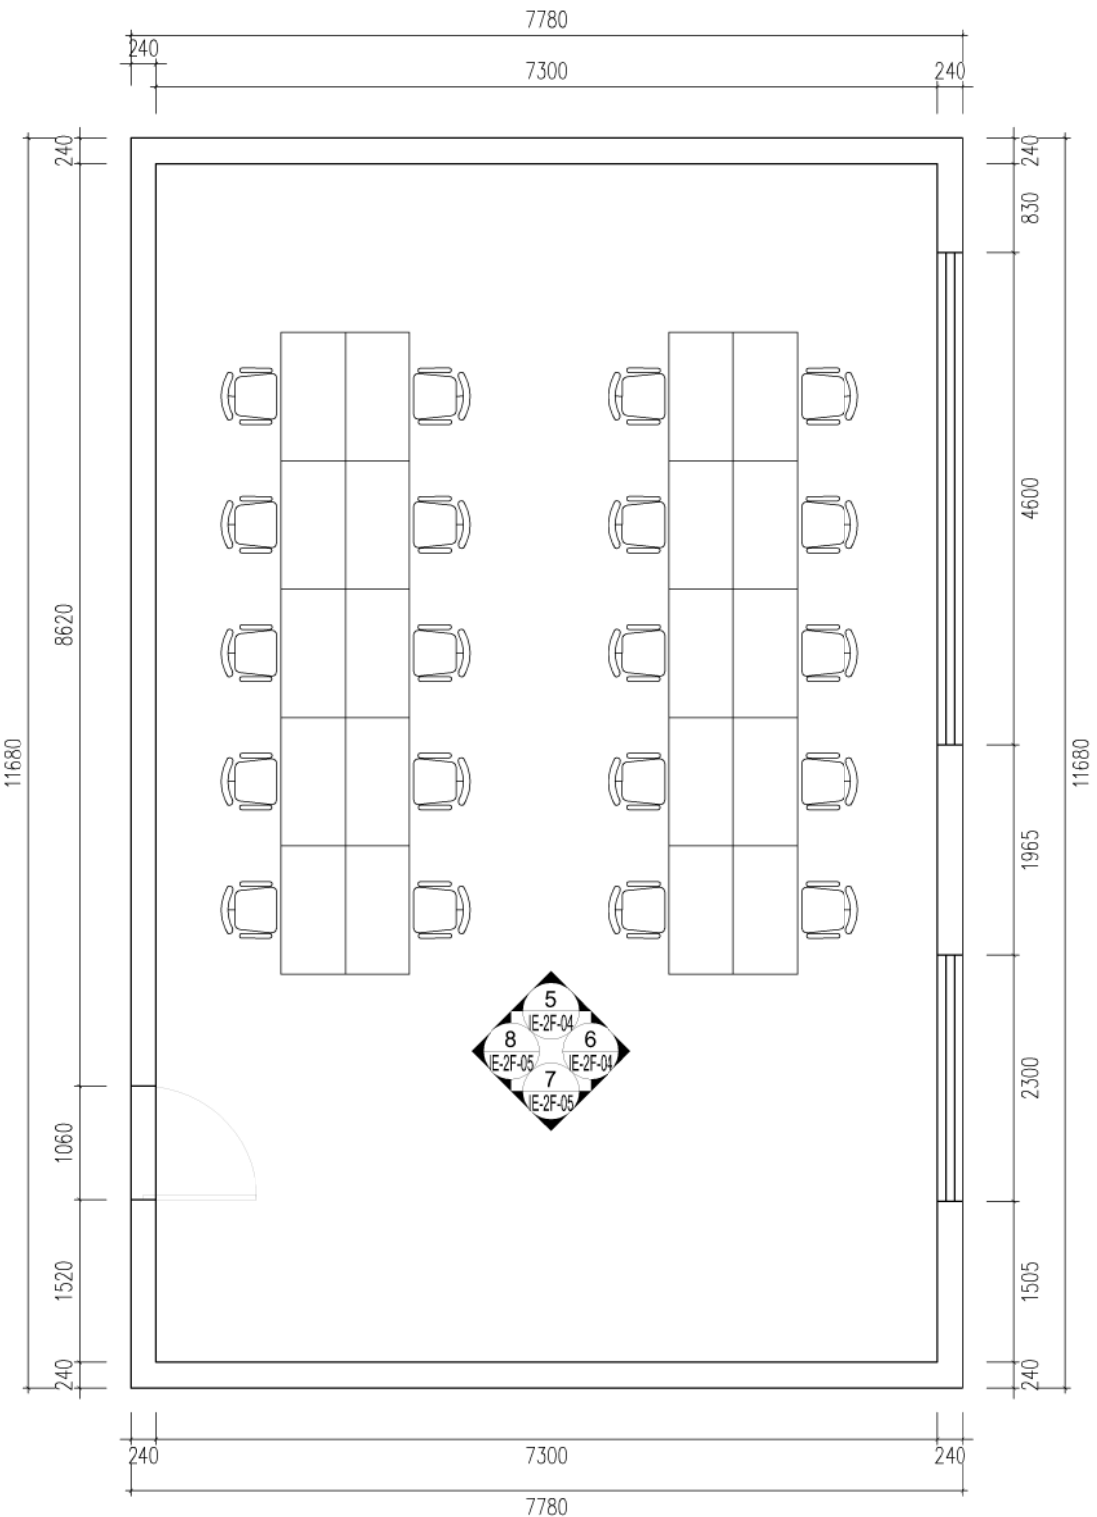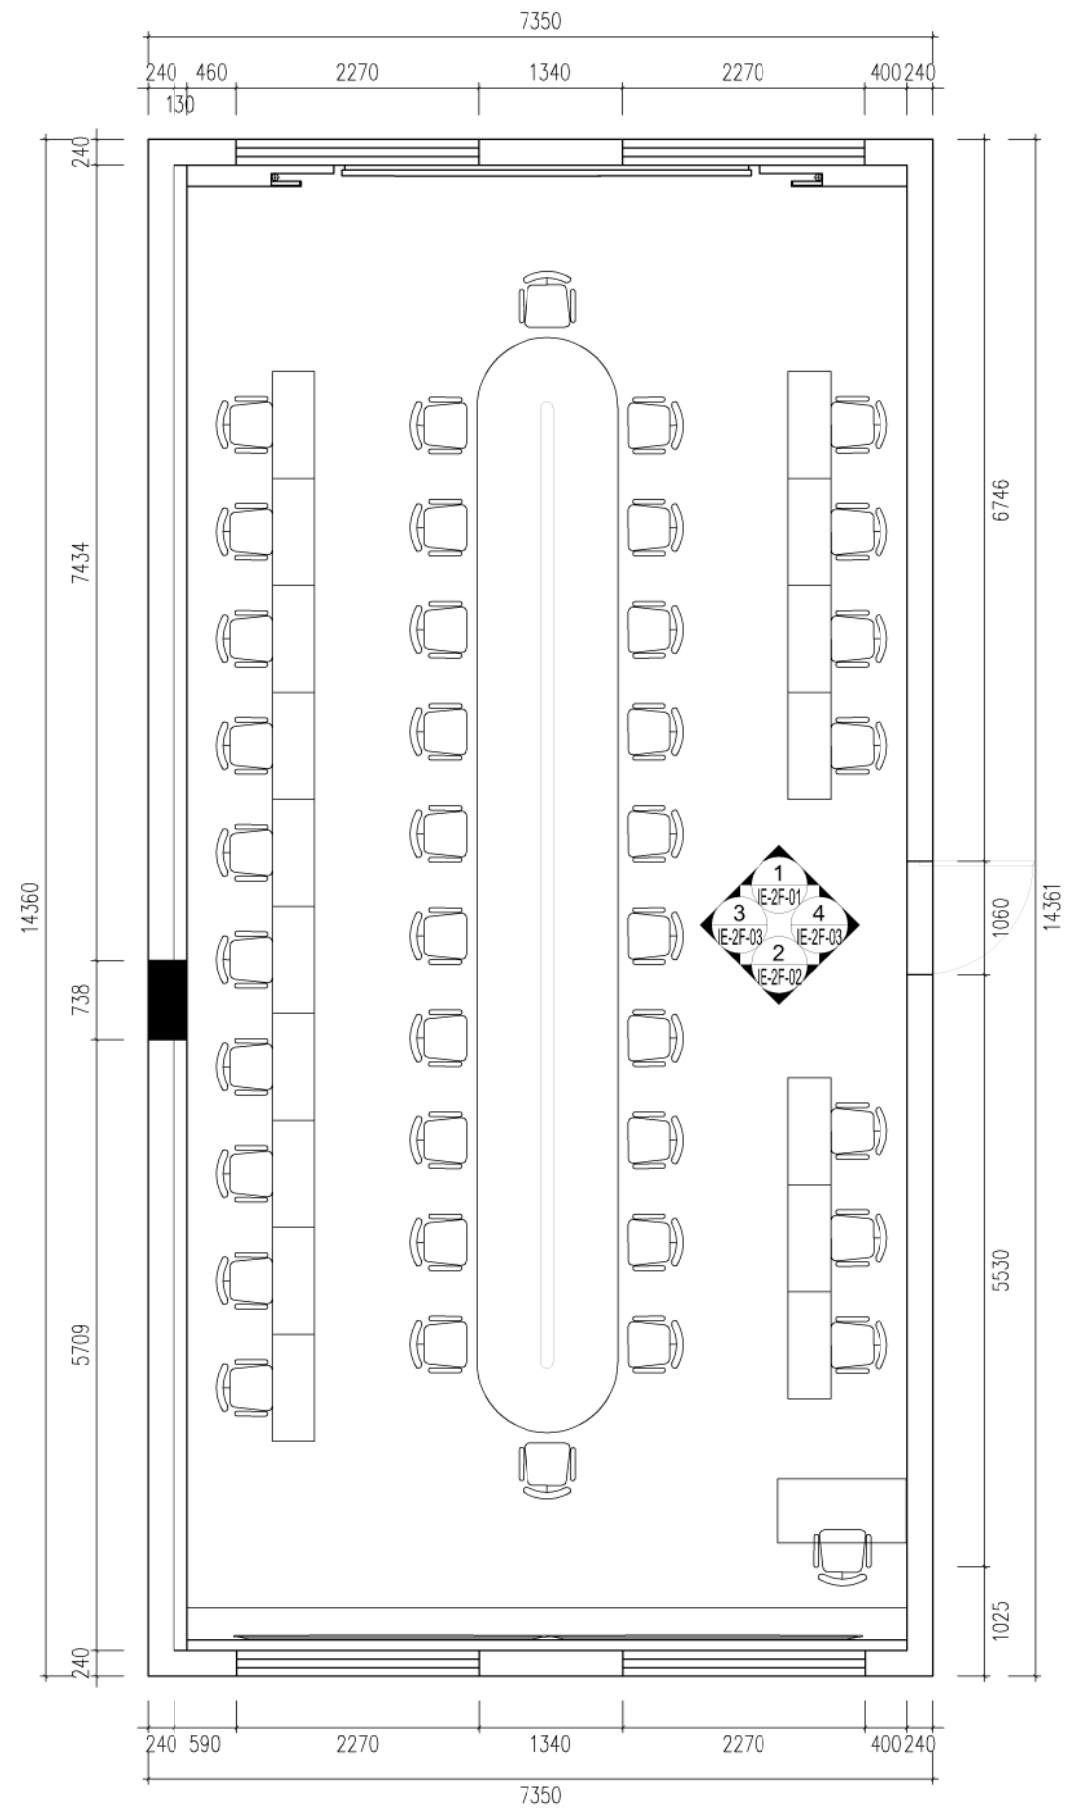

INDEX OF ELEVATION DRAWING
立面索引图

SCALE 1: 50

Copyright reserved. All information and copyright in this drawing and design are the property of the designer, and should not be used or reproduced without the consent of the Designer.
All drawings shall be verified by the contractor on site prior to the commencement of work.
本图版权归设计方所有，未经许可不得擅自复制或传播。
所有施工前应由承包商在现场核实。

PROJECT 项目		指挥大厅二层	
DRAWING TITLE 图名		立面索引图	
DRAWN 制图			
CHECKED 审核			
SCALE 比例		SCALE@ 1: 50	
PAGECOUNT 页码	19	DATE 日期	2026-03-24
PROJECT NO. 项目编号	01	VERSION NO. 版本号	1.0
DRAWING NO. 图号		P-2F-04	

FLOOR	PLAN	LEGENT
	↔↔	地材铺贴方向
	I=2%	地面导水坡度
	▼±0.000 F.F.L	地面相对标高
	石材	石材
	地板	地板
	瓷砖	瓷砖

TL 01
瓷砖
原始地面

TL 01
瓷砖
原始地面

▼ ±0.000 F.F.L

LOCATION MAP OF GROUND MATERIALS

地面材料铺装定位图

SCALE 1: 50

特种设备电源及相关线路需由专业部门提供方案

Copyright reserved. All information and copyright in this drawing and design are the property of the designer, and should not be used or reproduced without the consent of the Designer.
All drawings shall be verified by the contractor on site prior to the commencement of work.
本图版权归设计人所有，未经许可，不得复制或传播。
所有施工前应由承包商在现场核实。

PROJECT 项目

指挥大厅二层

DRAWING TITLE 图名

地面材料铺装定位图

DRAWN 制图

CHECKED 审核

SCALE 比例

SCALE@ 1:50

PAGE/COUNT 页码

19

DATE 日期

2026-03-24

PROJECT NO. 项目编号

01

VERSION NO. 版本

1.0



DRAWING NO. 图号

P-2F-05

图例	名称	高度(mm)	样式
	10A三孔插座	H:300	
	10A五孔插座	H:300	
	10A防水插座	H:300	
	16A三孔插座	H:见标注	
	一开五孔插座	H:1250	
	吸顶电源插座	暗装吊顶	
	地面电源插座	暗装地面	
	地面网络插座	暗装地面	
	电视有线插座	H:300	
	电话插座	H:300	
	网络插座	H:300	

说明:

- 除图纸内有标明插座高度以外, 其余均按表格内所注高度施工;
- 厨房水电以橱柜厂家设计为准;
- 插座高度[H]为成活地面到插座底沿的距离;
- 其他设备电源插座, 需由相关安装人员提供水电方案, 确认无误后方可施工;
- 若有大阳台或户外庭院, 则需预留灯线、插座线、水点等, 具体位置由设计厚根据现场实际情况确定;
- 全屋WIFI覆盖, 需相关厂家交底, 方可施工;

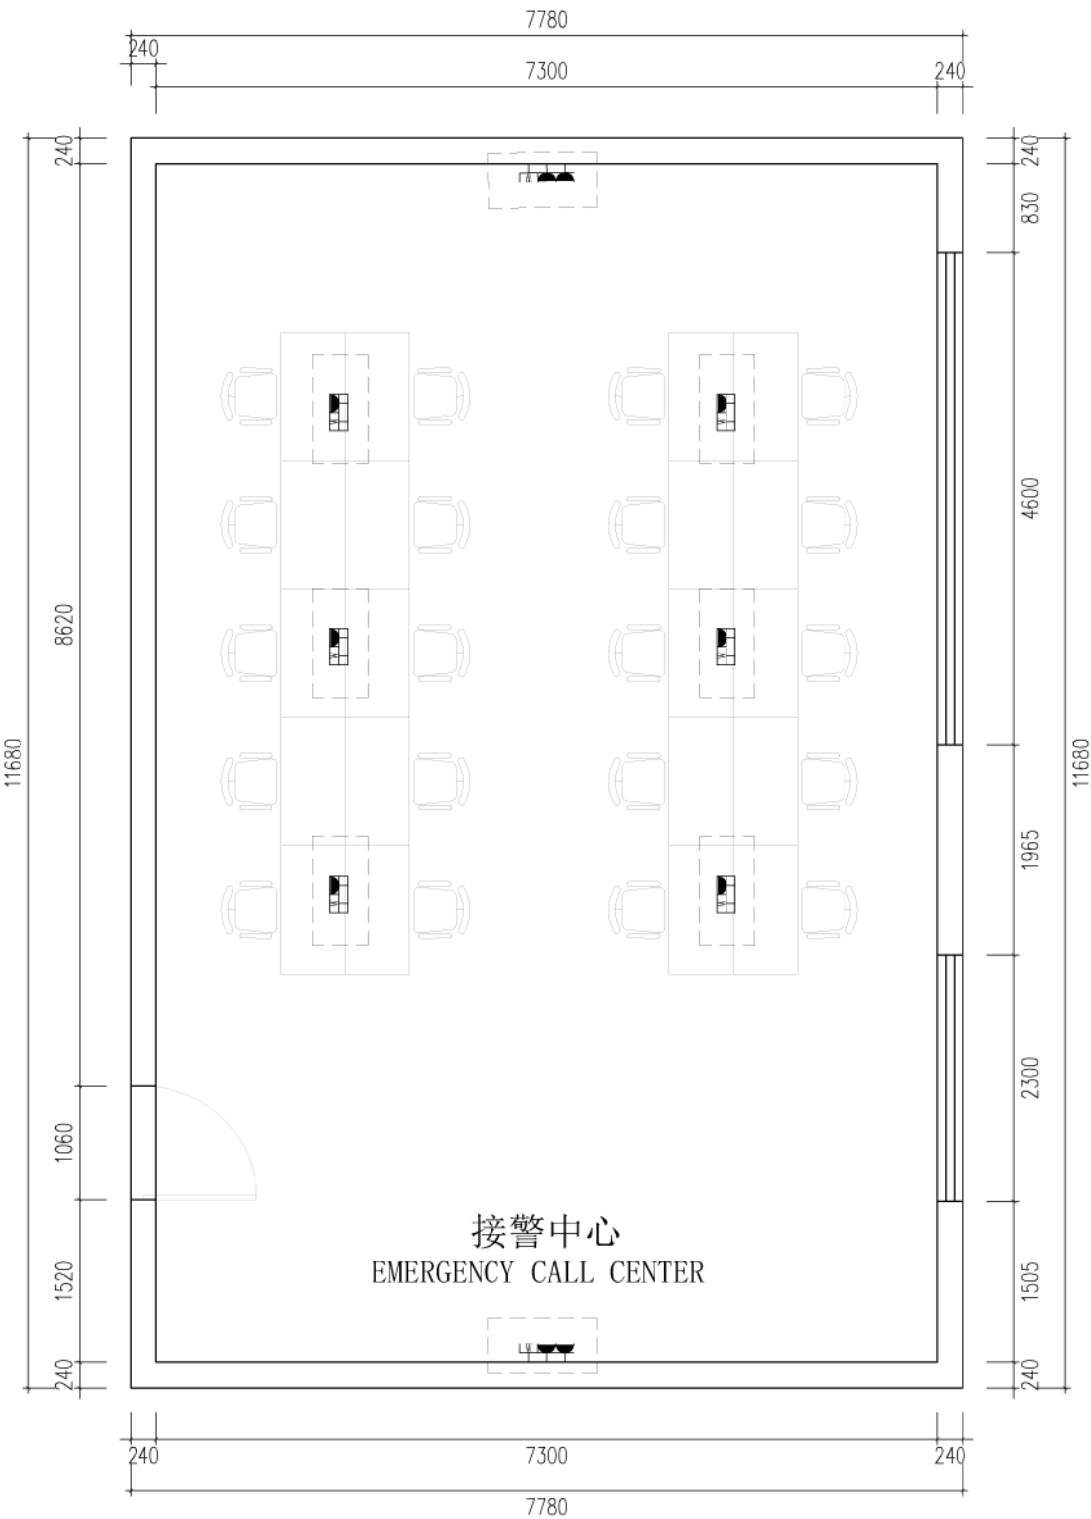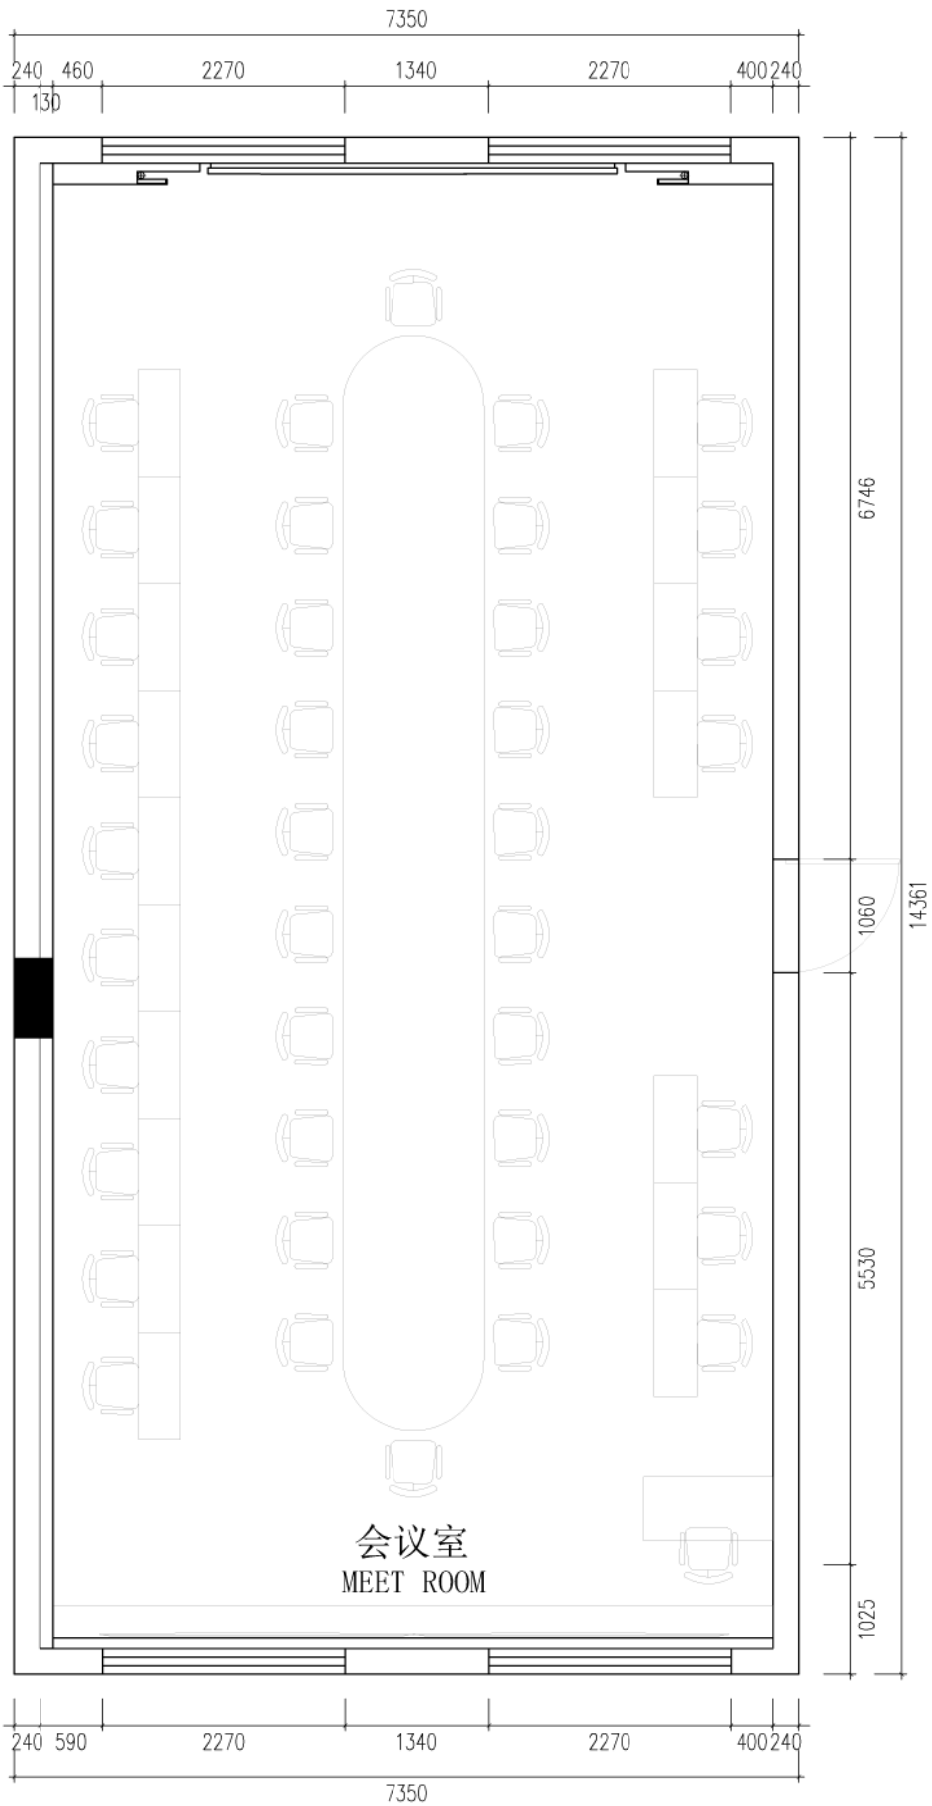

SWITCH SOCKET LOCATION DRAWING

开关插座定位图

SCALE 1: 50

特种设备电源及相关线路需由专业部门提供方案

Copyright reserved. All information and copyright in this drawing and design are the property of the designer, and should not be used or reproduced without the consent of the Designer.

本图纸及设计内容均为设计单位所有, 未经设计单位书面许可, 不得擅自复制或用于其他项目。

All dimensions shall be verified by the contractor on site prior to the commencement of work.

所有尺寸必须在施工前经现场核实。

PROJECT 项目

指挥大厅二层

DRAWING TITLE 图名

开关插座定位图

DRAWN 制图

CHECKED 审核

SCALE 比例

SCALE@ 1: 50

PAGE/COUNT 页码

19

DATE 日期

2026-03-24

PROJECT NO. 项目编号

01

VERSION NO. 版本

1.0

DRAWING NO. 图号

P-2F-06

Copyright reserved. All information and copyright in this drawing and design are the property of the designer, and should not be used or reproduced without the consent of the Designer.
All dimensions shall be verified by the contractor on site prior to the commencement of work.
本图版权归设计人所有, 未经许可, 不得复制或用于其他用途。
所有尺寸应在施工前由承包商在现场核实。

SCALE@ 1:25

PROJECT 项目

指挥大厅二层

DRAWING TITLE 图名

指挥大厅立面图
SCALE@ 1:25

DRAWN 制图

CHECKED 审核

SCALE 比例

PAGE/COUNT 页码



19 2026-03-24

PROJECT NO. 项目编号


01 1.0

DRAWING NO. 图号

IE-2F-01

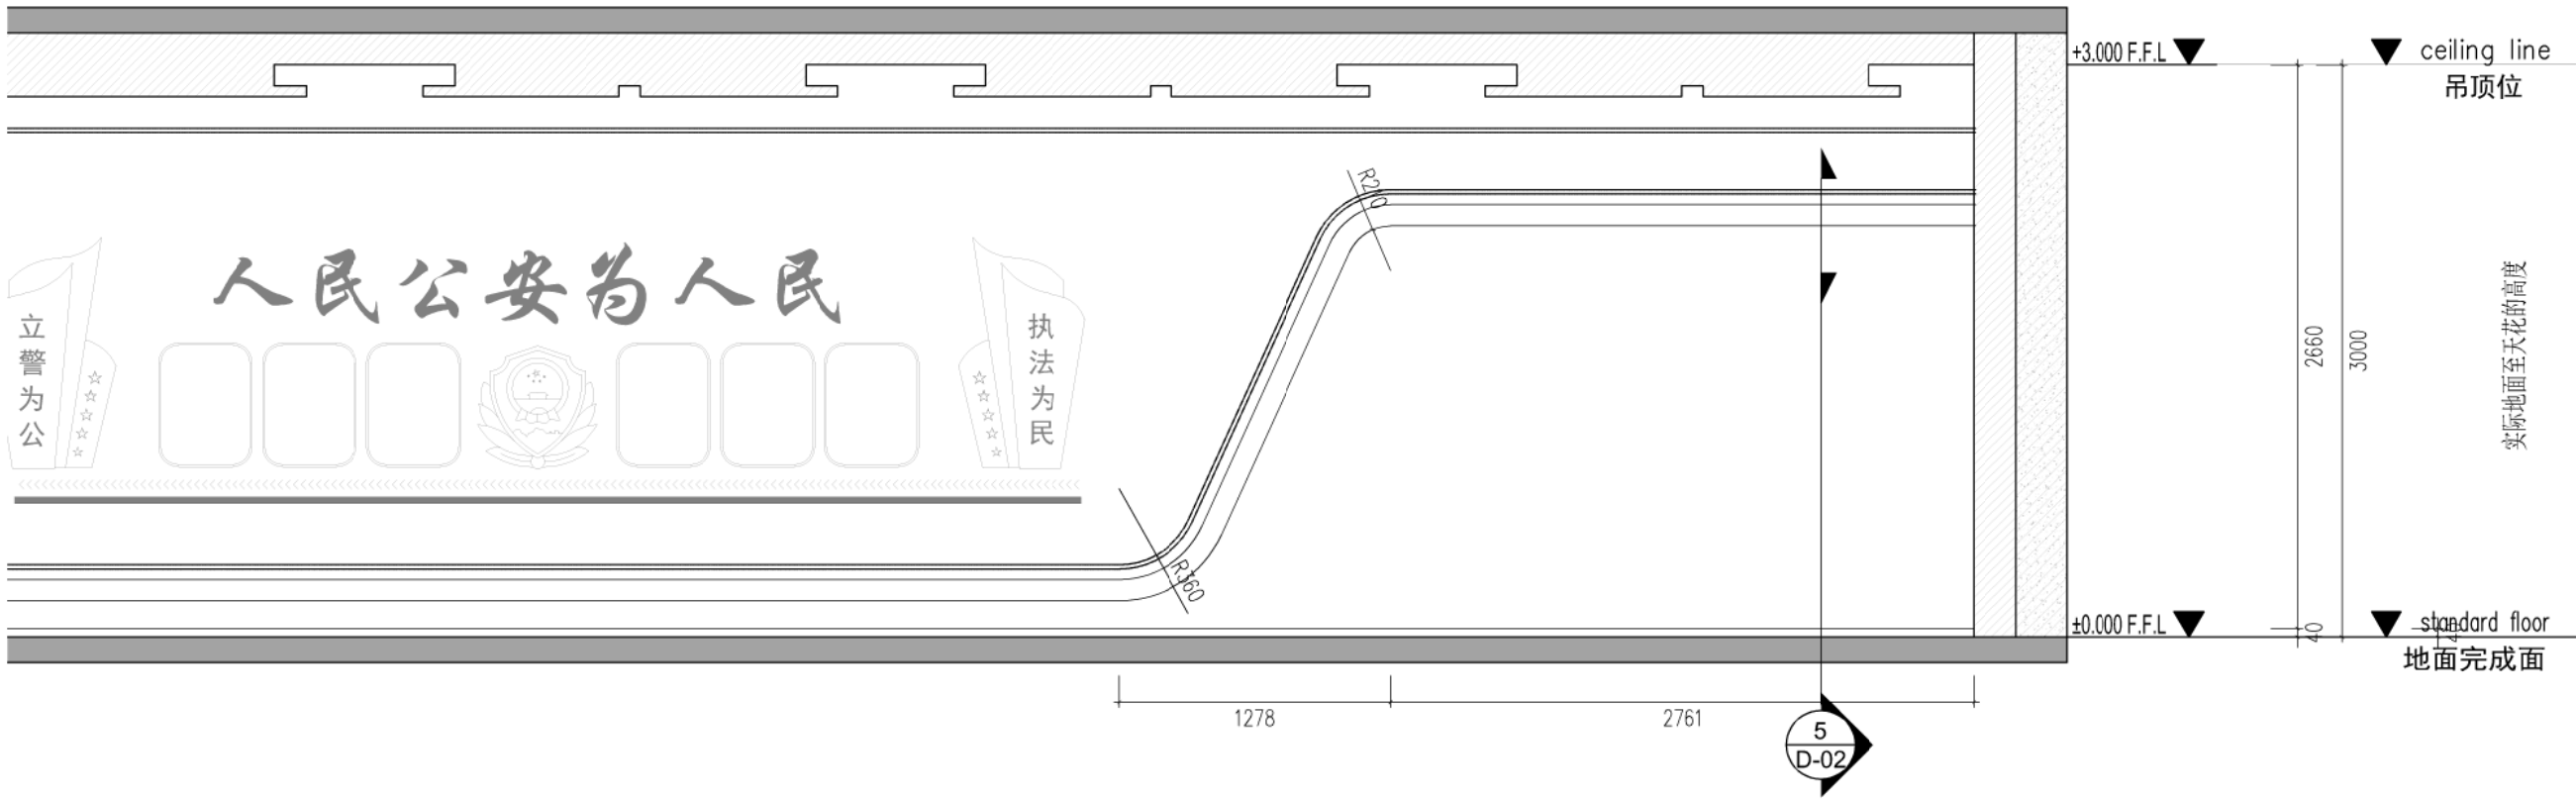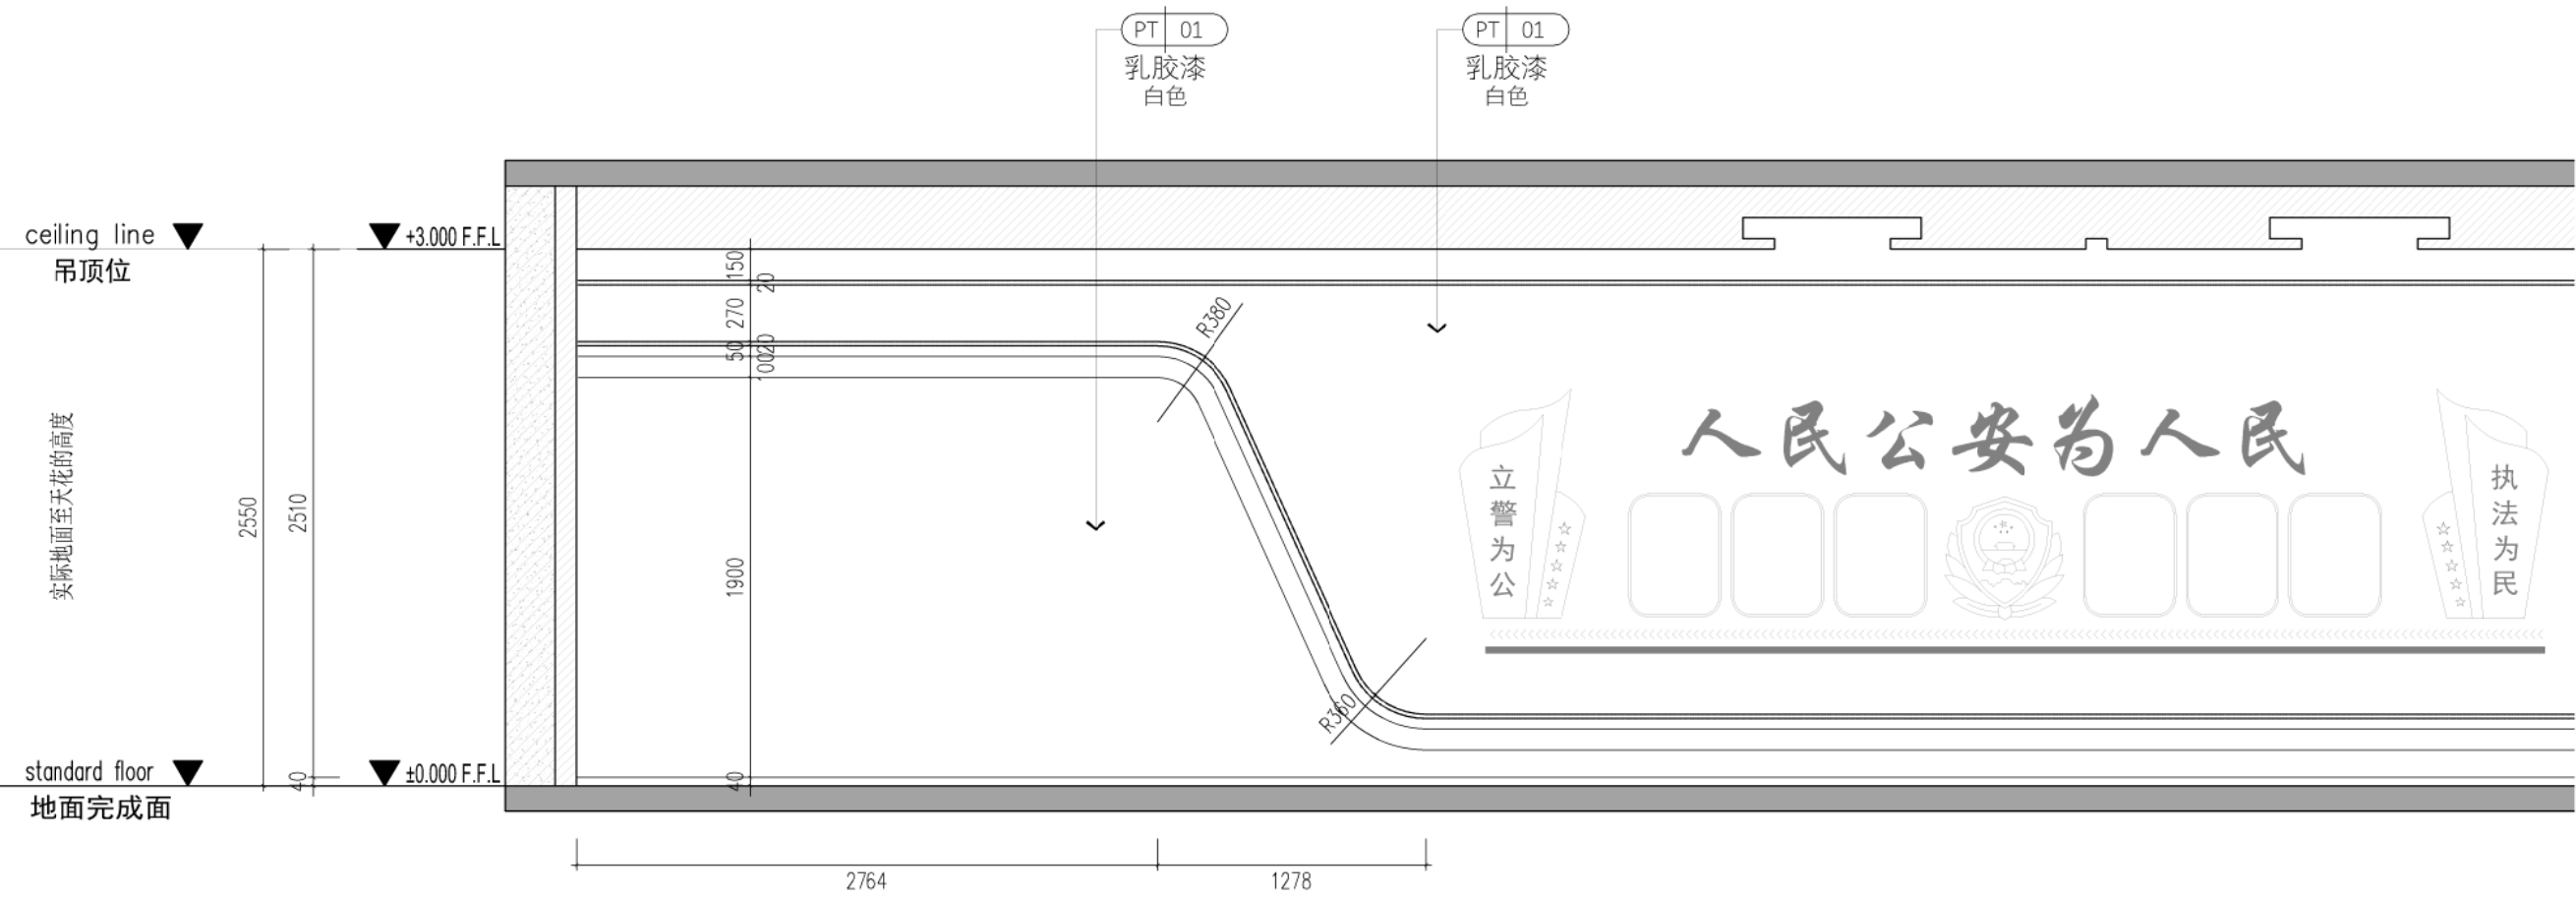

01 会议室立面图
SCALE: 1:25

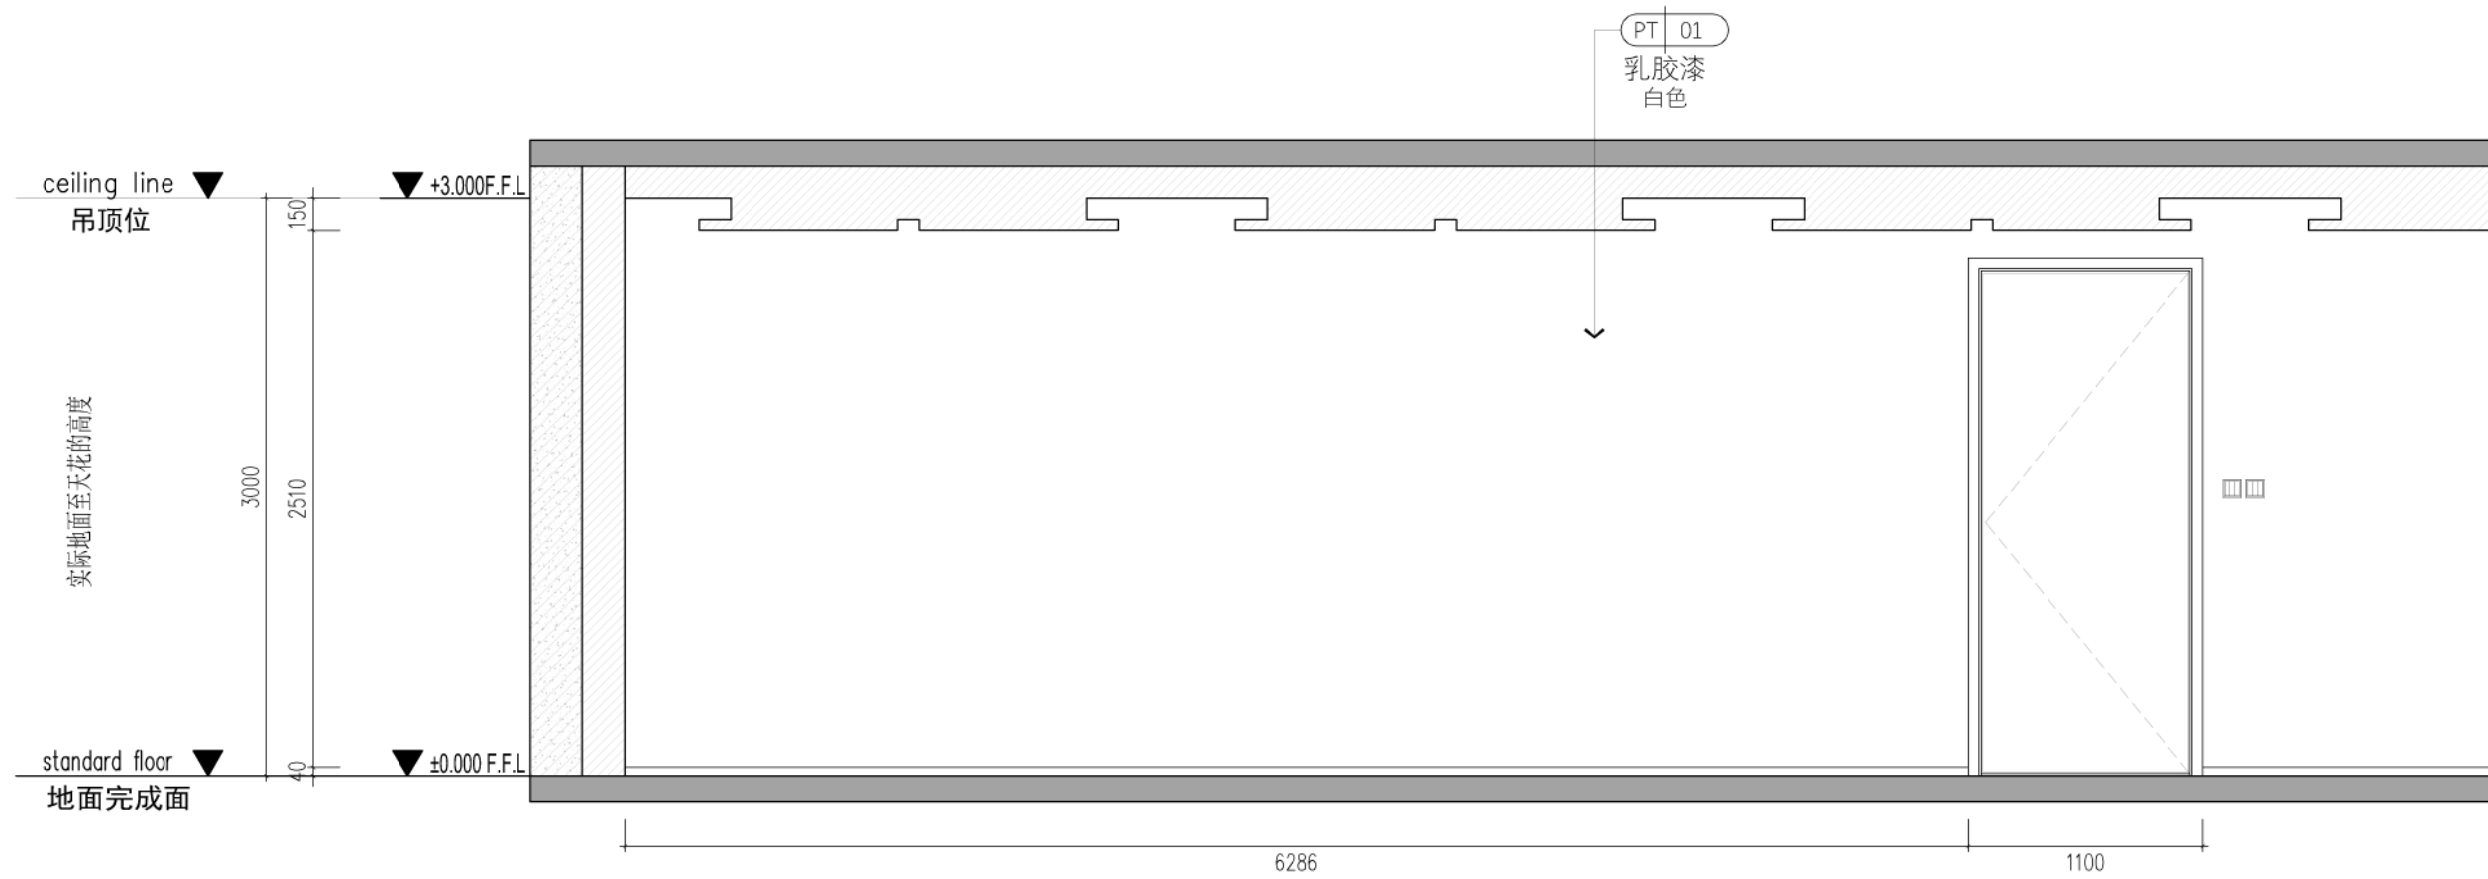


Copyright reserved. All information and copyright in this drawing and design are the property of the designer, and should not be used or reproduced without the consent of the Designer.

本图版权归设计单位所有, 未经许可, 不得擅自复制或传播。

All dimensions shall be verified by the contractor on site prior to the commencement of work.


施工前应复核尺寸, 在开始施工前进行复核。

SCALE@ 1:25

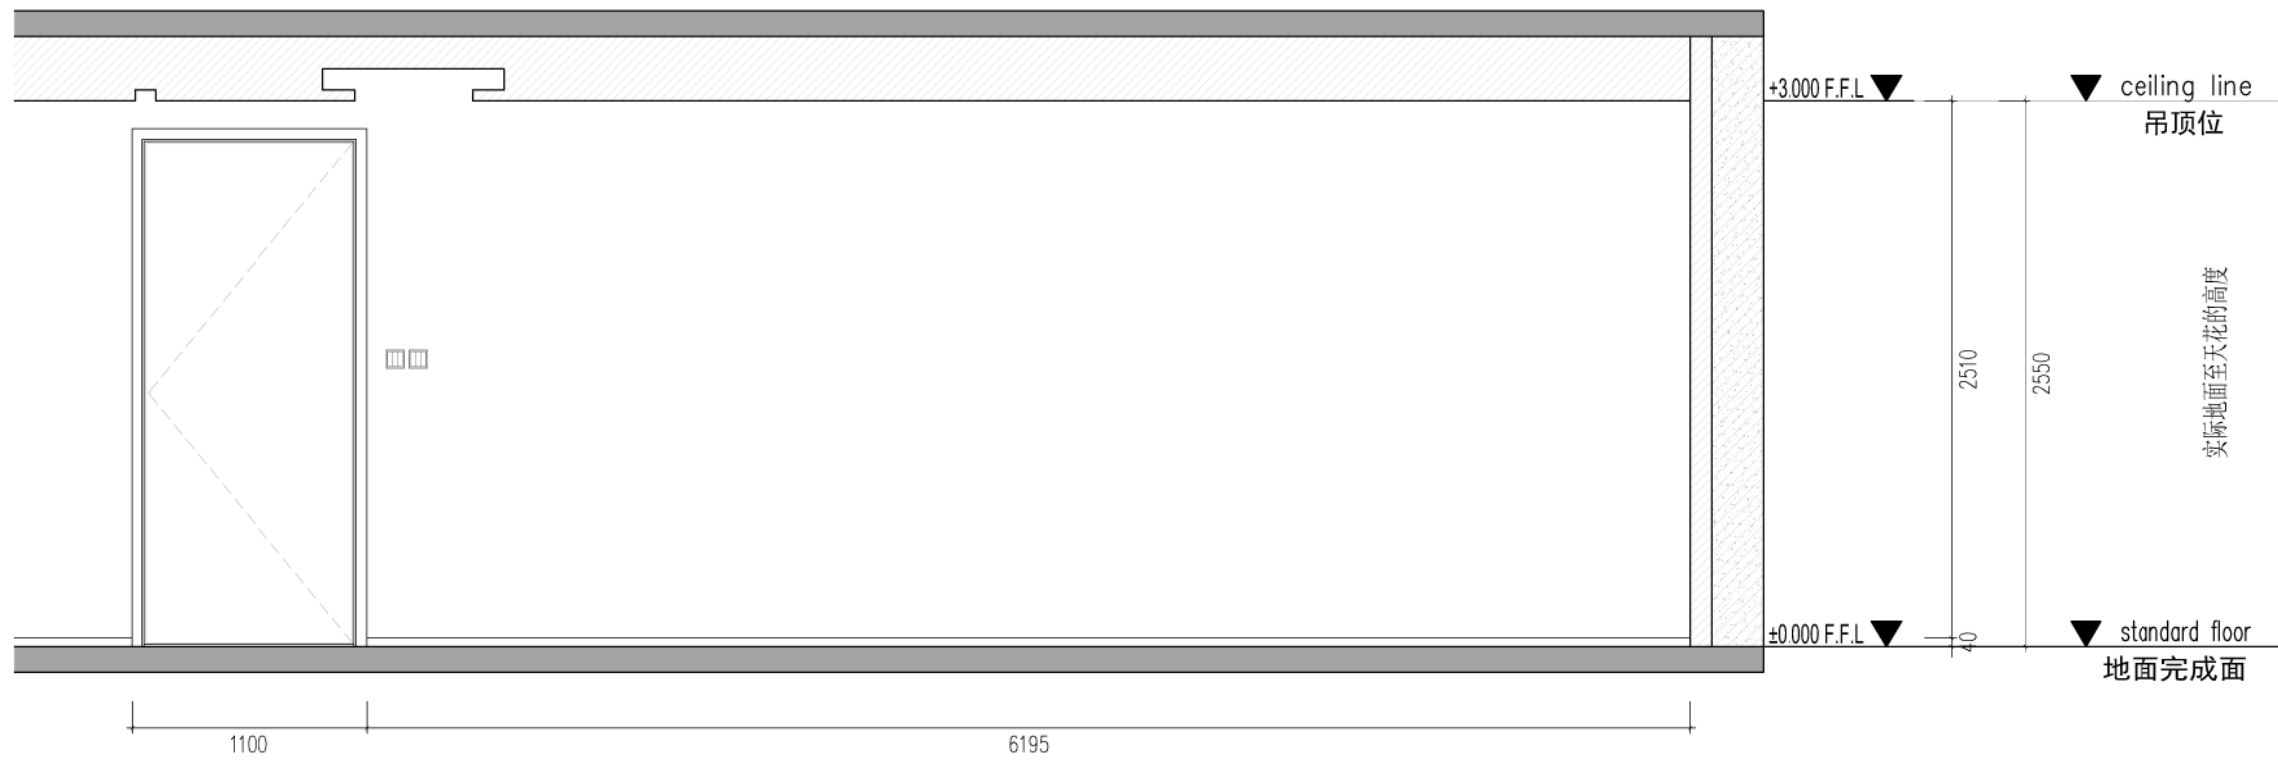

02 会议室立面图
SCALE: 1:25

PROJECT 项目	
指挥大厅二层	
DRAWING TITLE 图名	
指挥大厅立面图	
SCALE@ 1:25	
DRAWN 制图	
CHECKED 审核	
SCALE 比例	
PAGE/COUNT 页数	DATE 日期/月/年
19	2026-03-24
PROJECT NO. 项目编号	VERSION NO. 版次
01	1.0
DRAWING NO. 图号	
IE-2F-02	

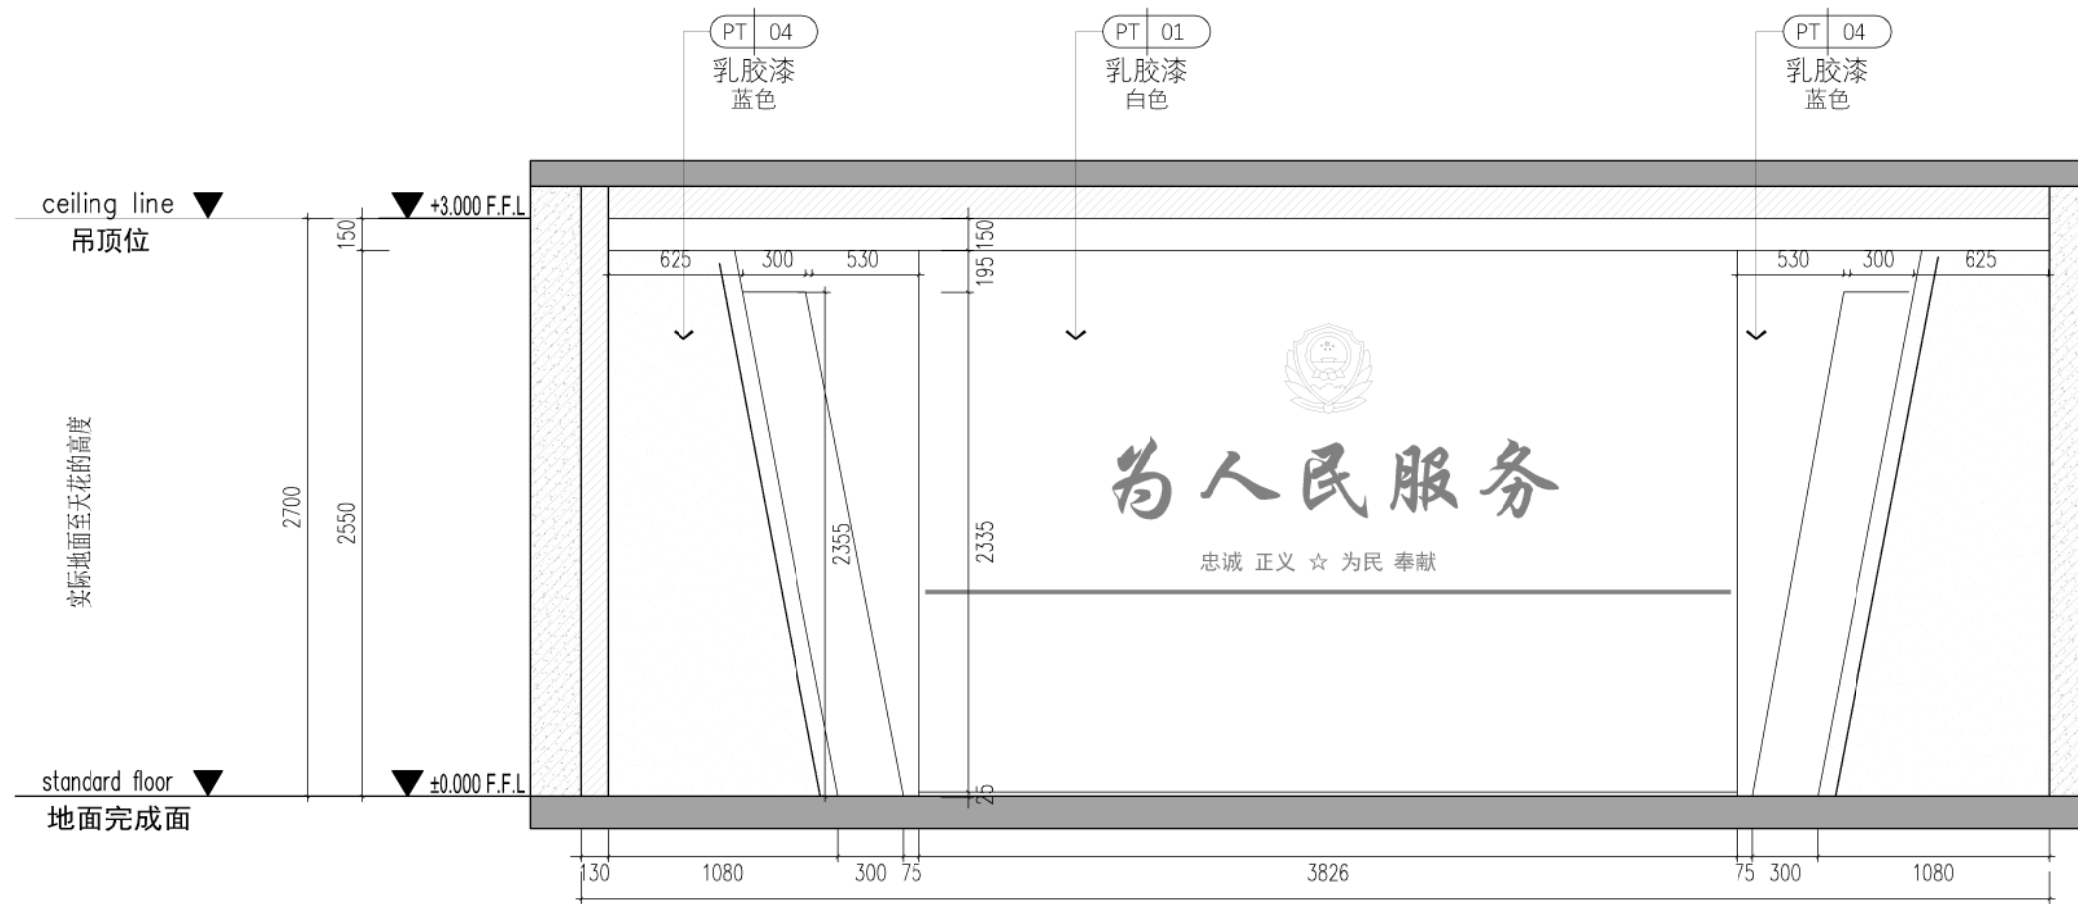

03 会议室立面图

SCALE: 1:35



04 会议室立面图

SCALE: 1:35

Copyright reserved. All information and copyright in this drawing and design are the property of the designer, and should not be used or reproduced without the consent of the Designer.

本图版权归设计单位所有，未经许可，不得擅自复制或用于其他项目。

All dimensions shall be verified by the contractor on site prior to the commencement of work.


本图尺寸须经现场核实，在开始施工前确认无误。

SCALE@ 1:25

PROJECT 项目	指挥大厅二层		
DRAWING TITLE 图名	指挥大厅立面图		
DRAWN 制图			
CHECKED 审核			
SCALE 比例	SCALE@ 1:25		
PAGE/COUNT 页码	19	DATE 日期	2026-03-24
PROJECT NO. 项目编号	01	VERSION NO. 版次	1.0
DRAWING NO. 图号	IE-2F-03		



05 接警室立面图
SCALE: 1:35

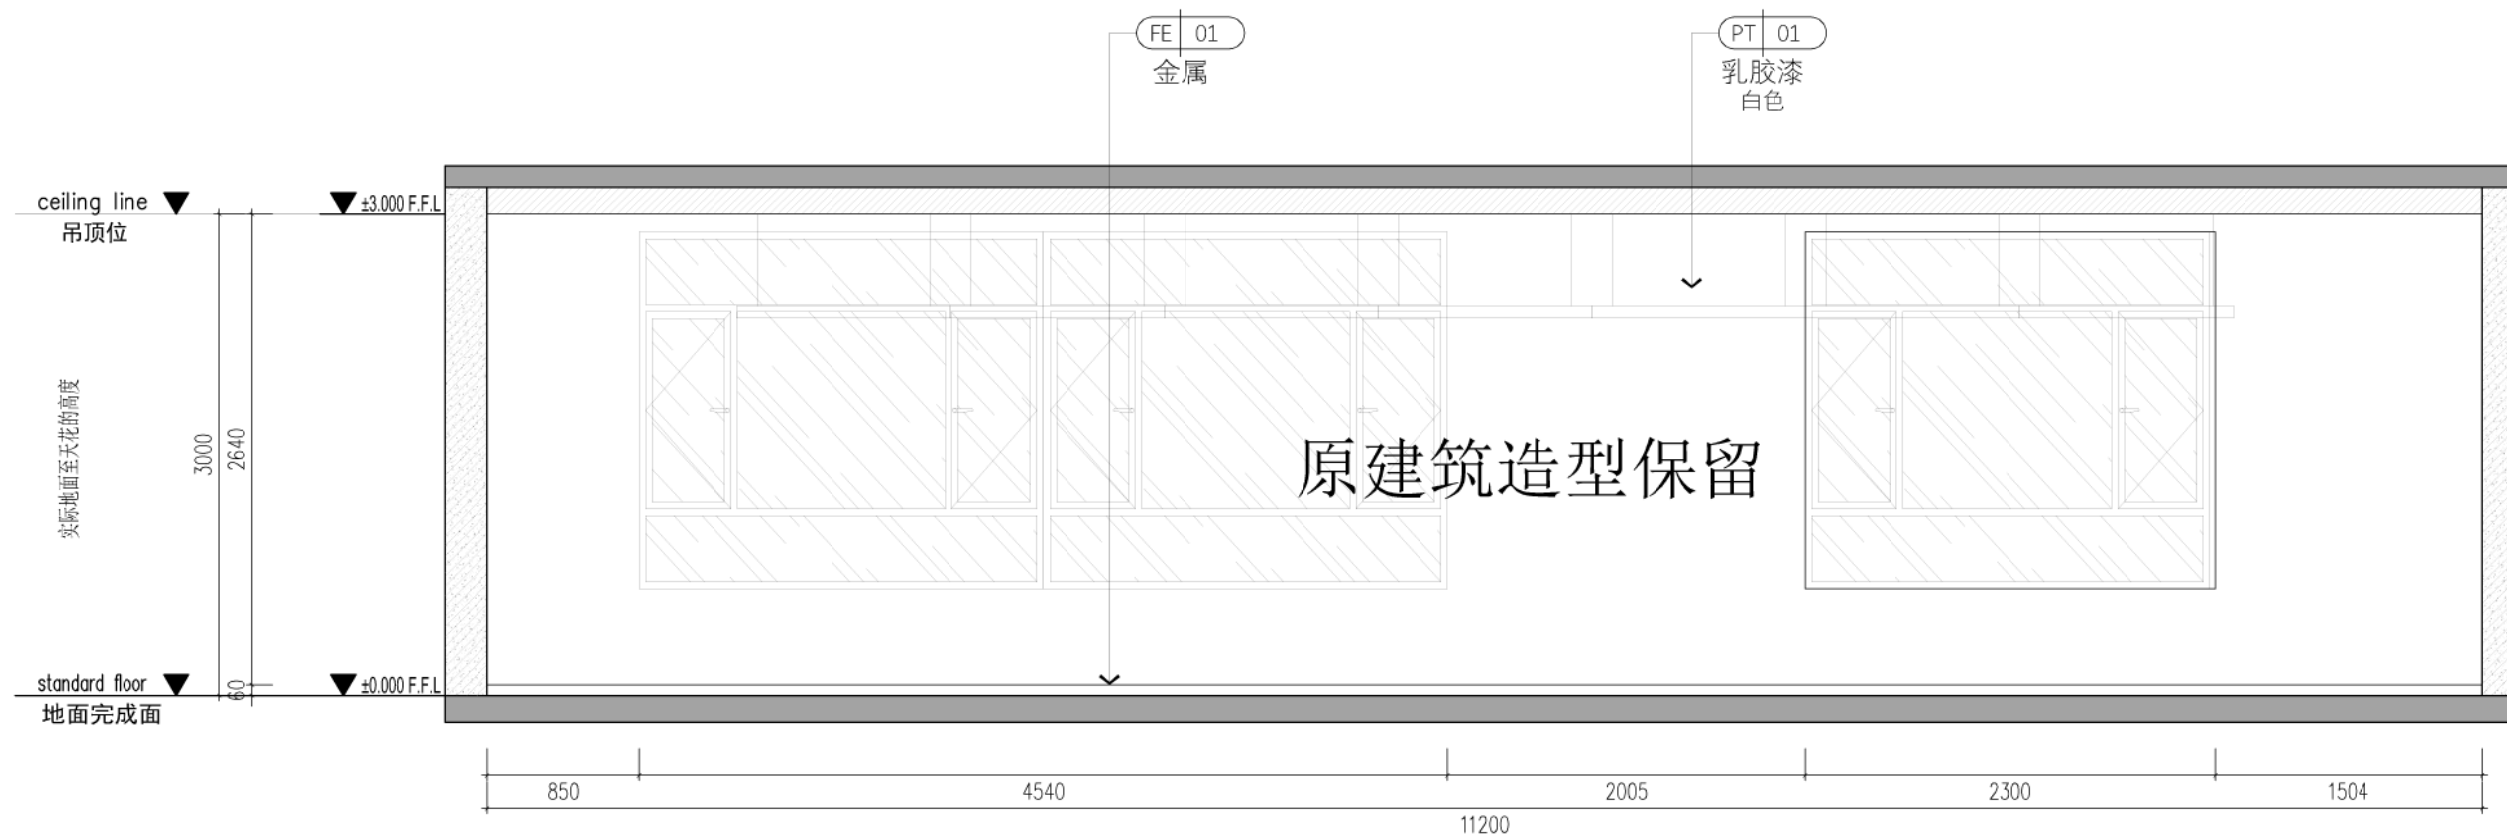

06 接警室立面图
SCALE: 1:35

Copyright reserved. All information and copyright in this drawing and design are the property of the designer, and should not be used or reproduced without the consent of the Designer.
All dimensions shall be verified by the contractor on site prior to the commencement of work.
本图版权归设计单位所有, 未经许可, 不得复制或用于其他工程。
所有尺寸须经施工方现场核实后方可施工。


SCALE@ 1:25

PROJECT 项目	
指挥大厅二层	
DRAWING TITLE 图名	
指挥大厅立面图	
DRAWN 制图	
CHECKED 审核	
SCALE 比例 SCALE@ 1:30	
PAGECOUNT 页码数 19	DATE 绘图日期 2026-03-24
PROJECT NO. 项目编号 01	VERSION NO. 版次 1.0
DRAWING NO. 图号 IE-2F-04	



07 接警室立面图

SCALE: 1:35

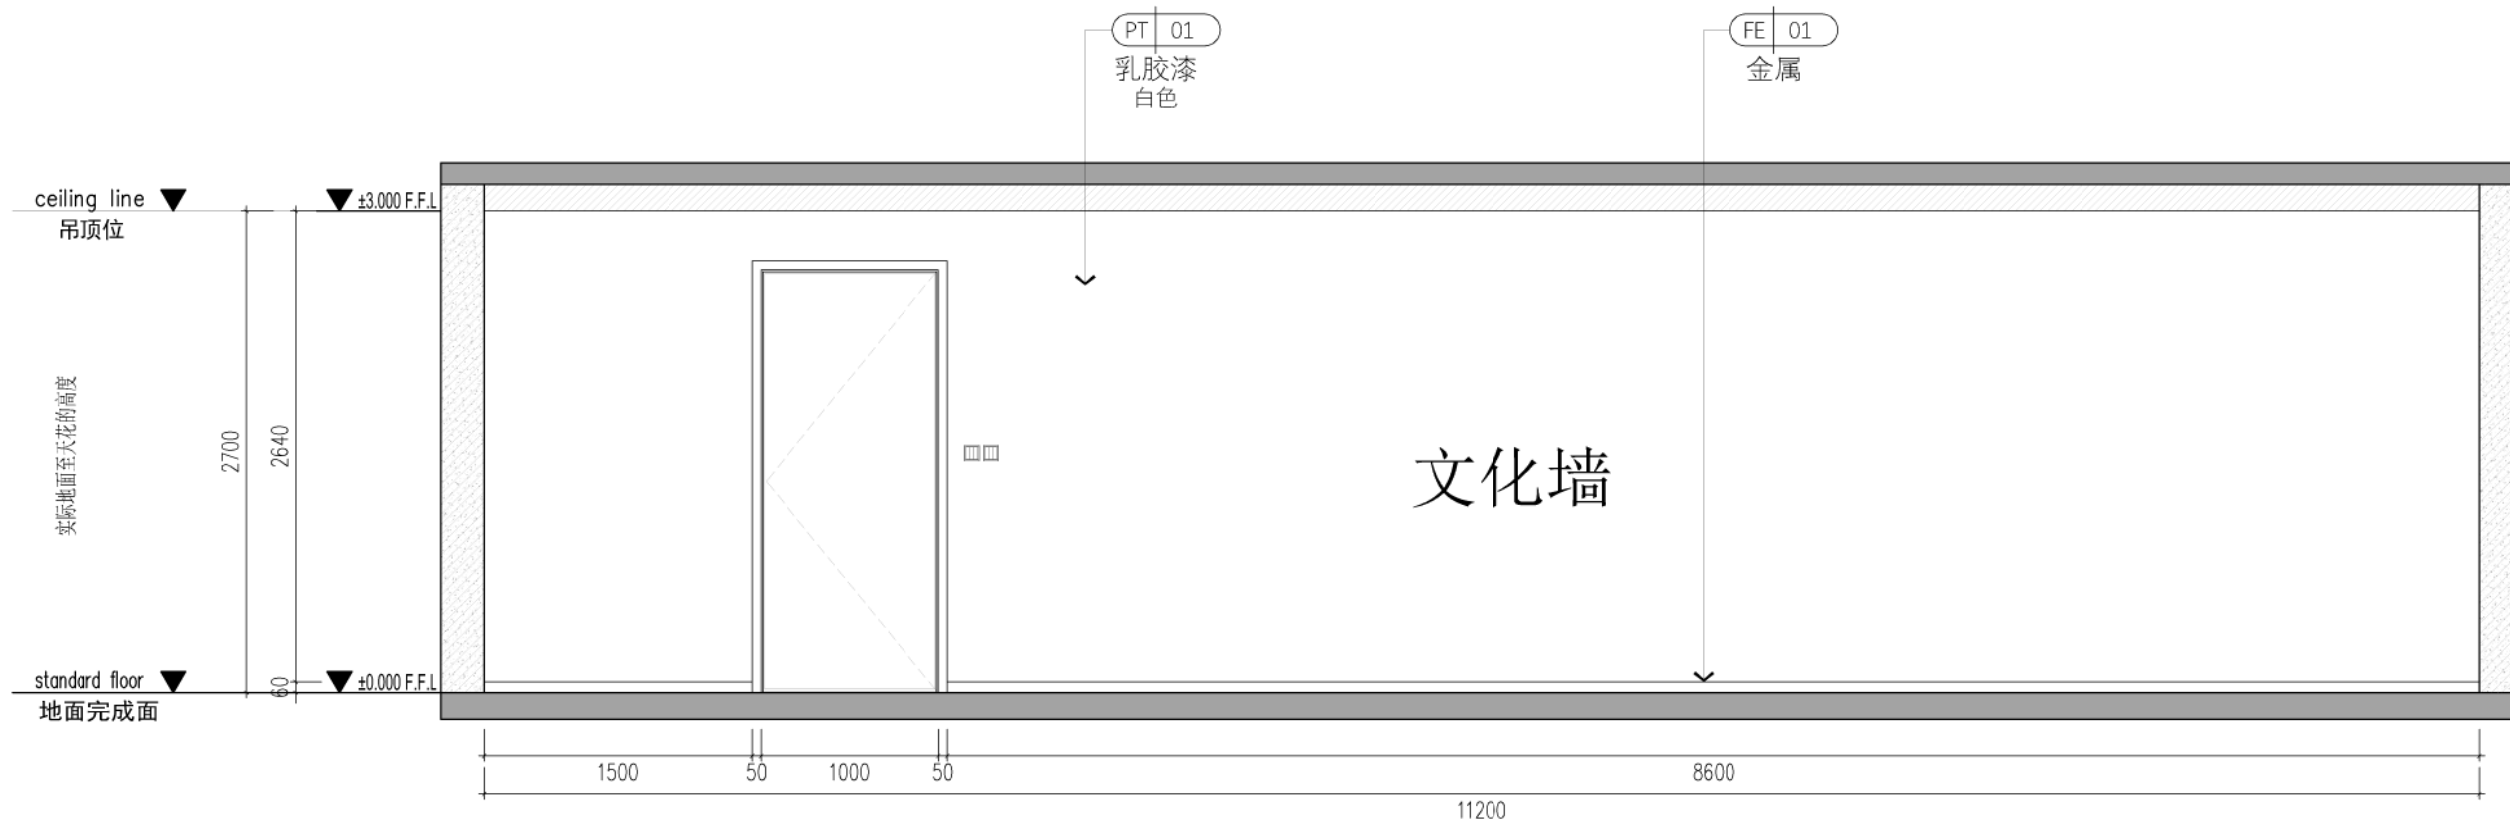

08 接警室立面图

SCALE: 1:40

Copyright reserved. All information and copyright in this drawing and design are the property of the designer, and should not be used or reproduced without the consent of the Designer.

本图版权归设计单位所有，未经许可，不得复制或用于其他项目。

All dimensions shall be verified by the contractor on site prior to the commencement of work.

施工过程中应核实所有尺寸，并在开始前进行确认。

SCALE@ 1:27

PROJECT 项目

指挥大厅二层

DRAWING TITLE 图名

指挥大厅立面图

DRAWN 制图

CHECKED 审核


SCALE 比例 SCALE@ 1:30

PAGECOUNT 页码 19 DATE 日期 2026-03-24

PROJECT NO. 项目编号 01 VERSION NO. 版本 1.0


DRAWING NO. 图号

IE-2F-05

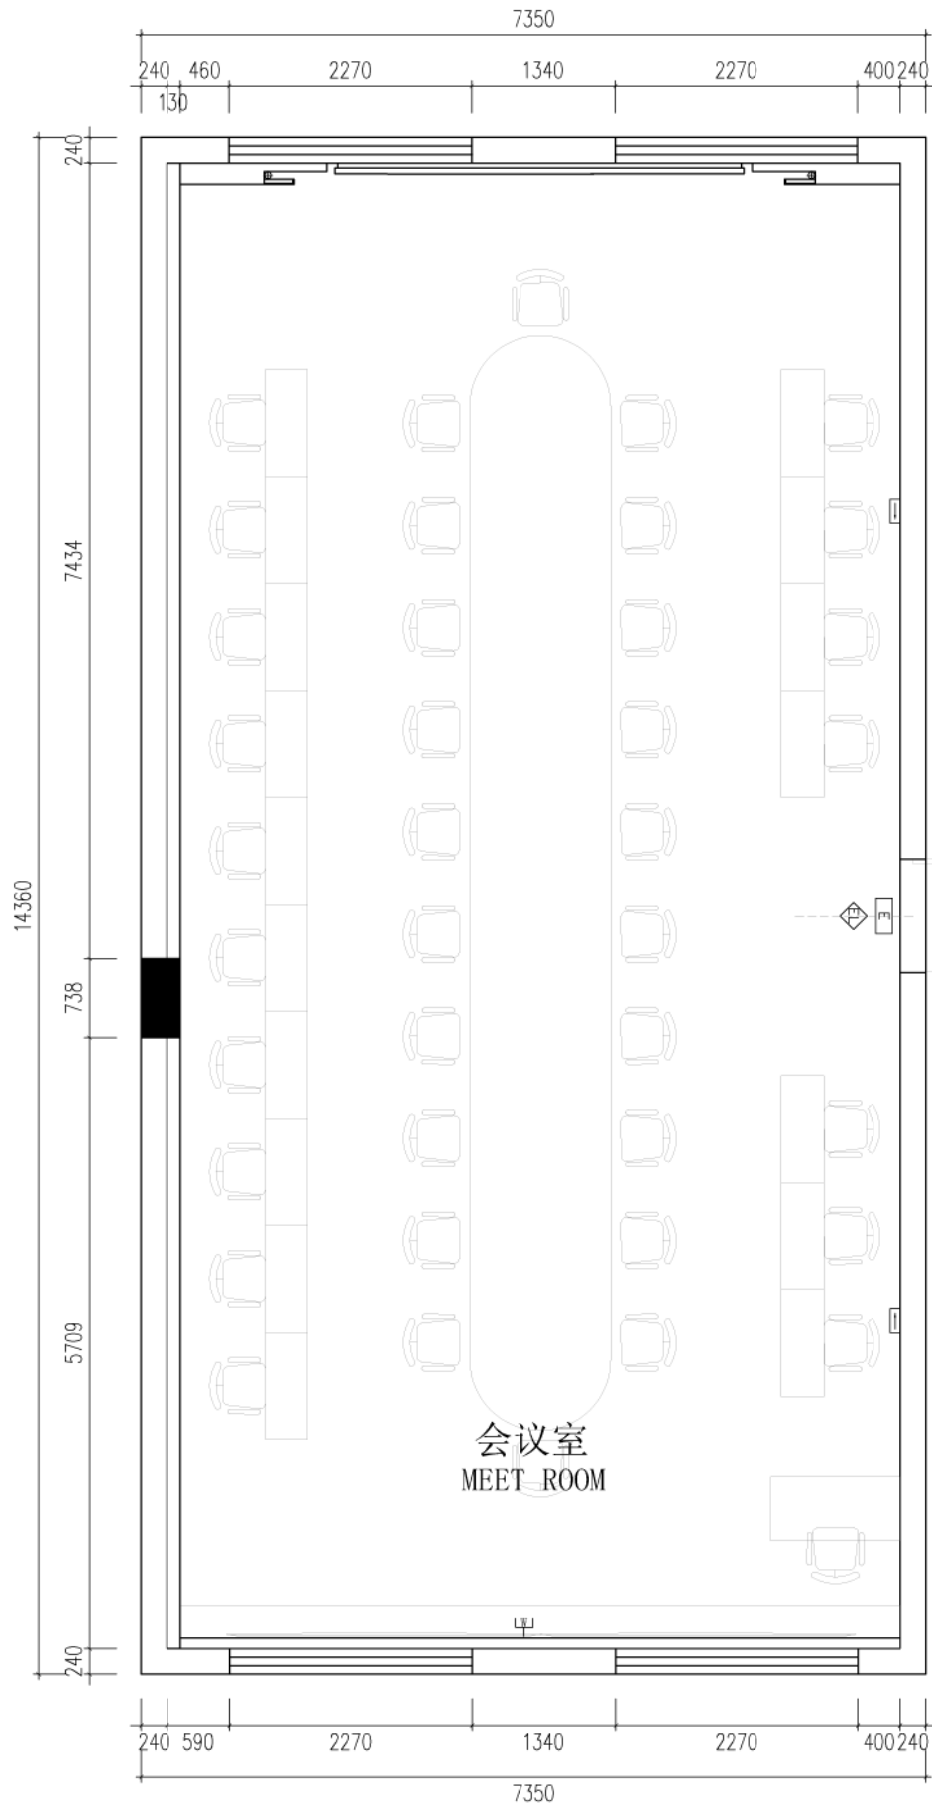

安防/无线设备		
序号	图例	说明
1		背景音乐
2		半球摄像机
3		摄像头
4		无线AP(顶装)
5		无线AP(墙装)
6		手机信号放大器
7		红外幕帘(顶装)
8		红外幕帘(墙装)

喷淋/烟感/报警		
序号	图例	说明
1		喷淋
2		烟感
3		晶感
4		消防扬声器
5		燃气探测器

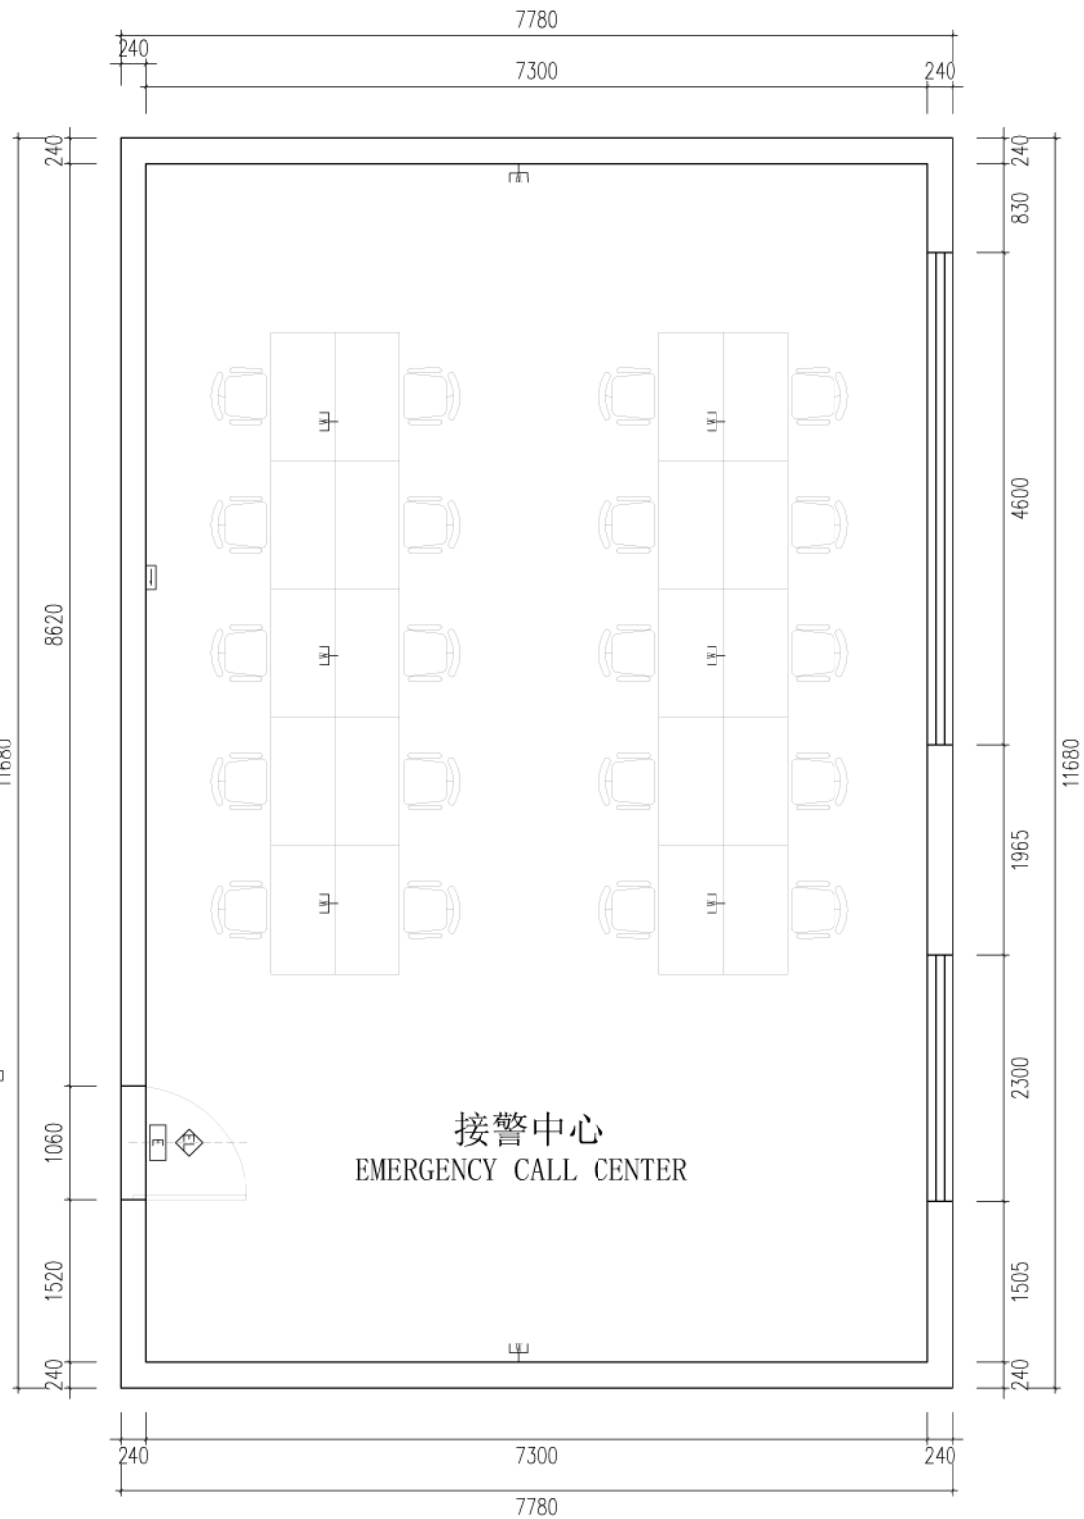

SWITCH SOCKET LOCATION DRAWING
地面机电点位图
SCALE 1:70

天花设备安装需确定数量和位置后配合灯具调整
特种设备电源及相关线路需由专业部门提供方案

Copyright reserved. All information and copyright in this drawing and design are the property of the designer, and should not be used or reproduced without the consent of the Designer.
本图纸及设计内容均受法律保护，未经许可，不得擅自复制或传播。
All dimensions shall be verified by the contractor on site prior to the commencement of work.
施工前应现场核实尺寸，在开始施工前进行确认。

PROJECT 项目		指挥大厅二层	
DRAWING TITLE 图名		开关插座定位图	
DRAWN 制图			
CHECKED 审核			
SCALE 比例			
PAGECOUNT 页码	19	DATE 日期	2026-03-24
PROJECT NO. 项目编号	01	VERSION NO. 版本号	1.0
DRAWING NO. 图号		U-2F-1	